

Perez & Partners, Inc.  
architecture

ARCHITECT  
Jorge I. Perez, AIA  
AR 95576  
Perez & Partners, Inc.  
AA 26002942  
7720 SW 89 Ct  
Miami, FL 33173  
786.543.9093  
jorge@perezandpartners.com

CLIENT/PROJECT NAME

INTERIOR RENOVATIONS TO  
THE PRESTIGE HOTEL  
(East Building)  
1526 OCEAN DRIVE  
VERO BEACH, FLORIDA 32963

CONSULTANTS

STRUCTURAL ENGINEER:  
Adolfo J. Gonzalez, PE  
2050 Coral Way #502  
Miami, FL 33145  
305.415.8782  
adolfojgonzalezpe@gmail.com

MEP ENGINEER:  
Treasure Coast  
Engineering, Inc.  
4925 13th Lane  
Vero Beach, FL 32966  
772.567.1007  
www.tce.eng.pro

ISSUE/REVISIONS

No.	DATE	DESCRIPTION
-	9-14-15	PERMIT SUBMITTAL

PROJECT No. 15-03

DRAWN BY:

 
 
CHECKED BY:

SEAL

 
 
 
 
 
 

 
 
 




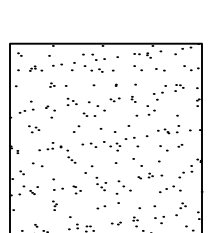
SHEET No.

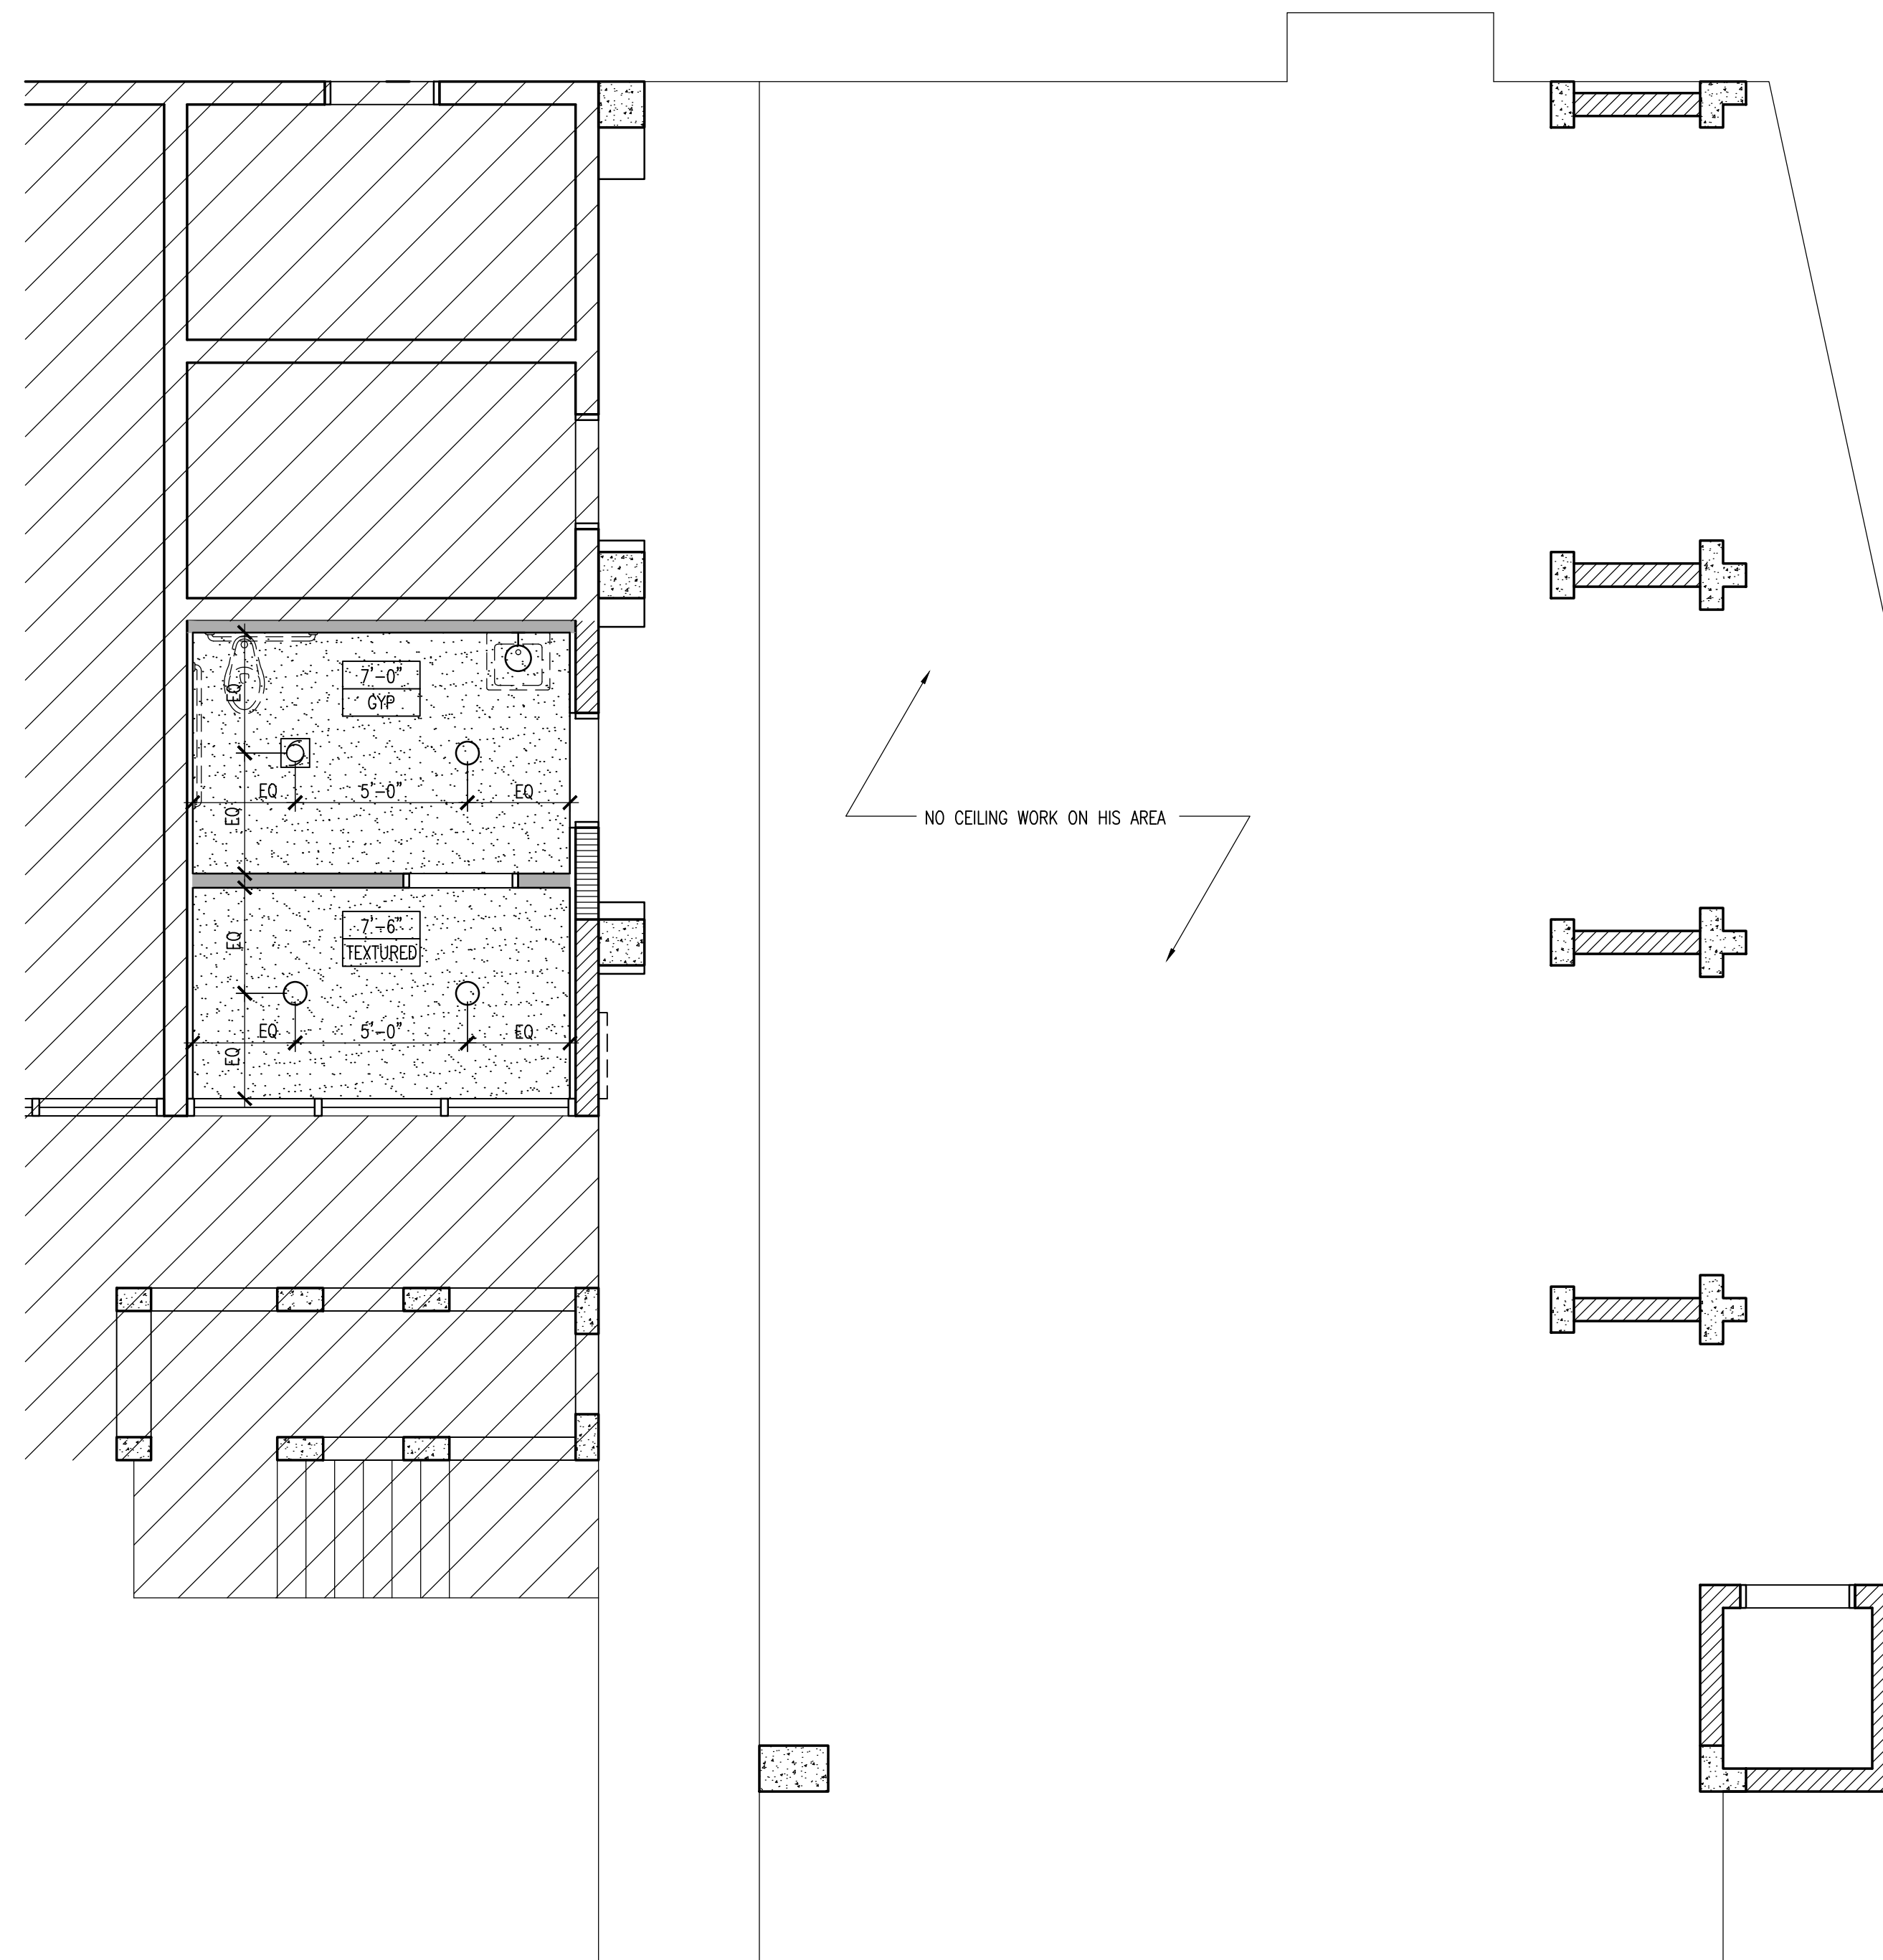
A2.31

### CEILING MATERIAL KEY

-  FINISH CEILING HEIGHT ABOVE FINISH FLOOR (E) EXISTING TO REMAIN
-  CEILING MATERIAL NUMBER DESIGNATES TYPE AND/OR FINISH
- (E) EXISTING TO REMAIN
- ACP-1 ACOUSTICAL CEILING PANEL
- GYP GYPSUM BOARD CEILING
- STU CEMENT PLASTER (INTERIOR)/STUCCO (EXTERIOR) CEILING
- TEXTURED TEXTURED "POPCORN" CEILING
- EXPOSED EXPOSED UNDERSIDE OF FLOOR OR ROOF STRUCTURE

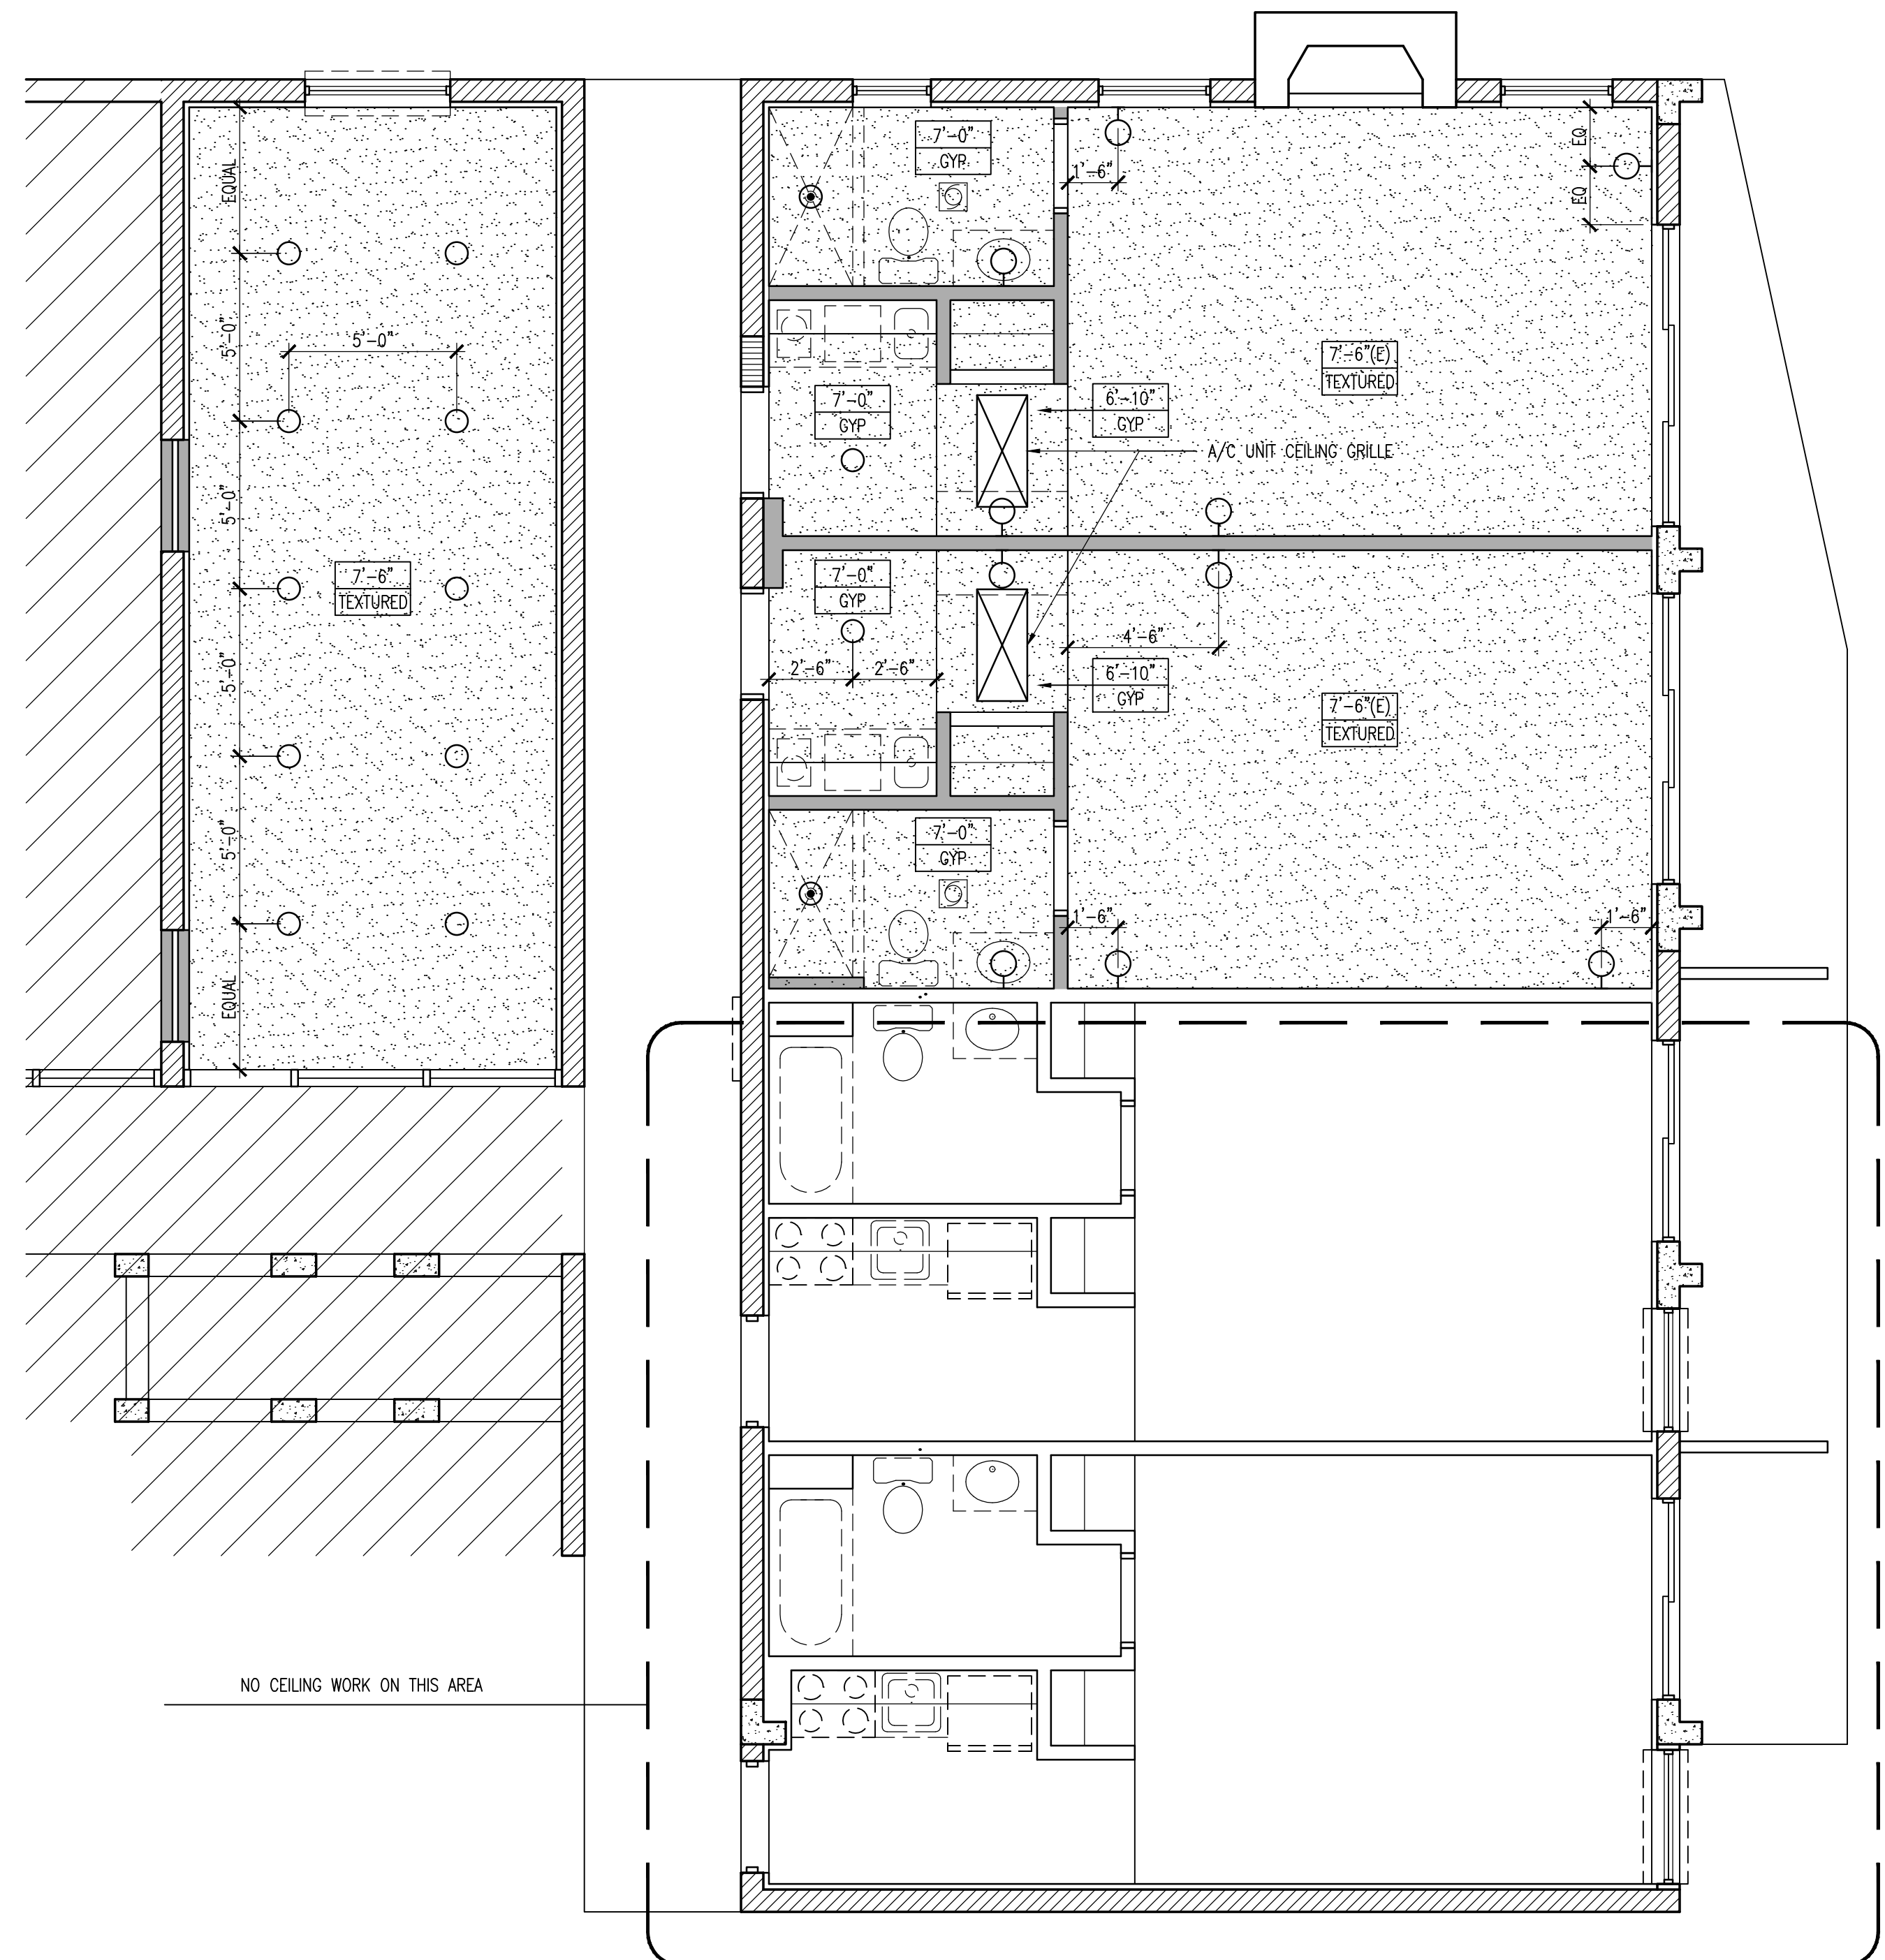
 
### CEILING LEGEND

-  ROOF OR CEILING ACCESS PANEL
-  SUPPLY CEILING DIFFUSER, SEE MECHANICAL DRAWINGS FOR DUCTING
-  RETURN OR EXHAUST GRILLE, SEE MECHANICAL DRAWINGS FOR DUCTING
-  RECESSED MOUNTED FLUORESCENT LIGHT FIXTURE, SEE ELECTRICAL DRAWINGS FOR TYPE
-  1'x4' SUSPENDED LIGHT FIXTURE, SEE ELECTRICAL DRAWINGS FOR TYPE
-  SURFACE MOUNTED FLUORESCENT LIGHT FIXTURE, SEE ELECTRICAL DRAWINGS FOR TYPE
-  RECESSED OR SURFACE MOUNTED DOWN LIGHT, SEE ELECTRICAL DRAWINGS FOR TYPE
-  RECESSED OR SURFACE MOUNTED DOWN LIGHT, WET RATED, SEE ELECT. DRAWINGS FOR TYPE
-  WALL MOUNTED LIGHT FIXTURE, SEE ELECTRICAL DRAWINGS FOR TYPE
-  CEILING MOUNTED J-BOX
-  EXHAUST FAN WITH LIGHT
-  WALL MOUNTED EMERGENCY EXIT SIGN
-  CEILING MOUNTED EMERGENCY EXIT SIGN
-  CEILING MOUNTED EMERGENCY EXIT SIGN WITH DIRECTION OF TRAVEL
-  GYPSUM BOARD CEILING



1 FIRST FLOOR REFLECTED CEILING PLAN

SCALE: 1/4" = 1'-0"



2 SECOND FLOOR REFLECTED CEILING PLAN

SCALE: 1/4" = 1'-0"

