


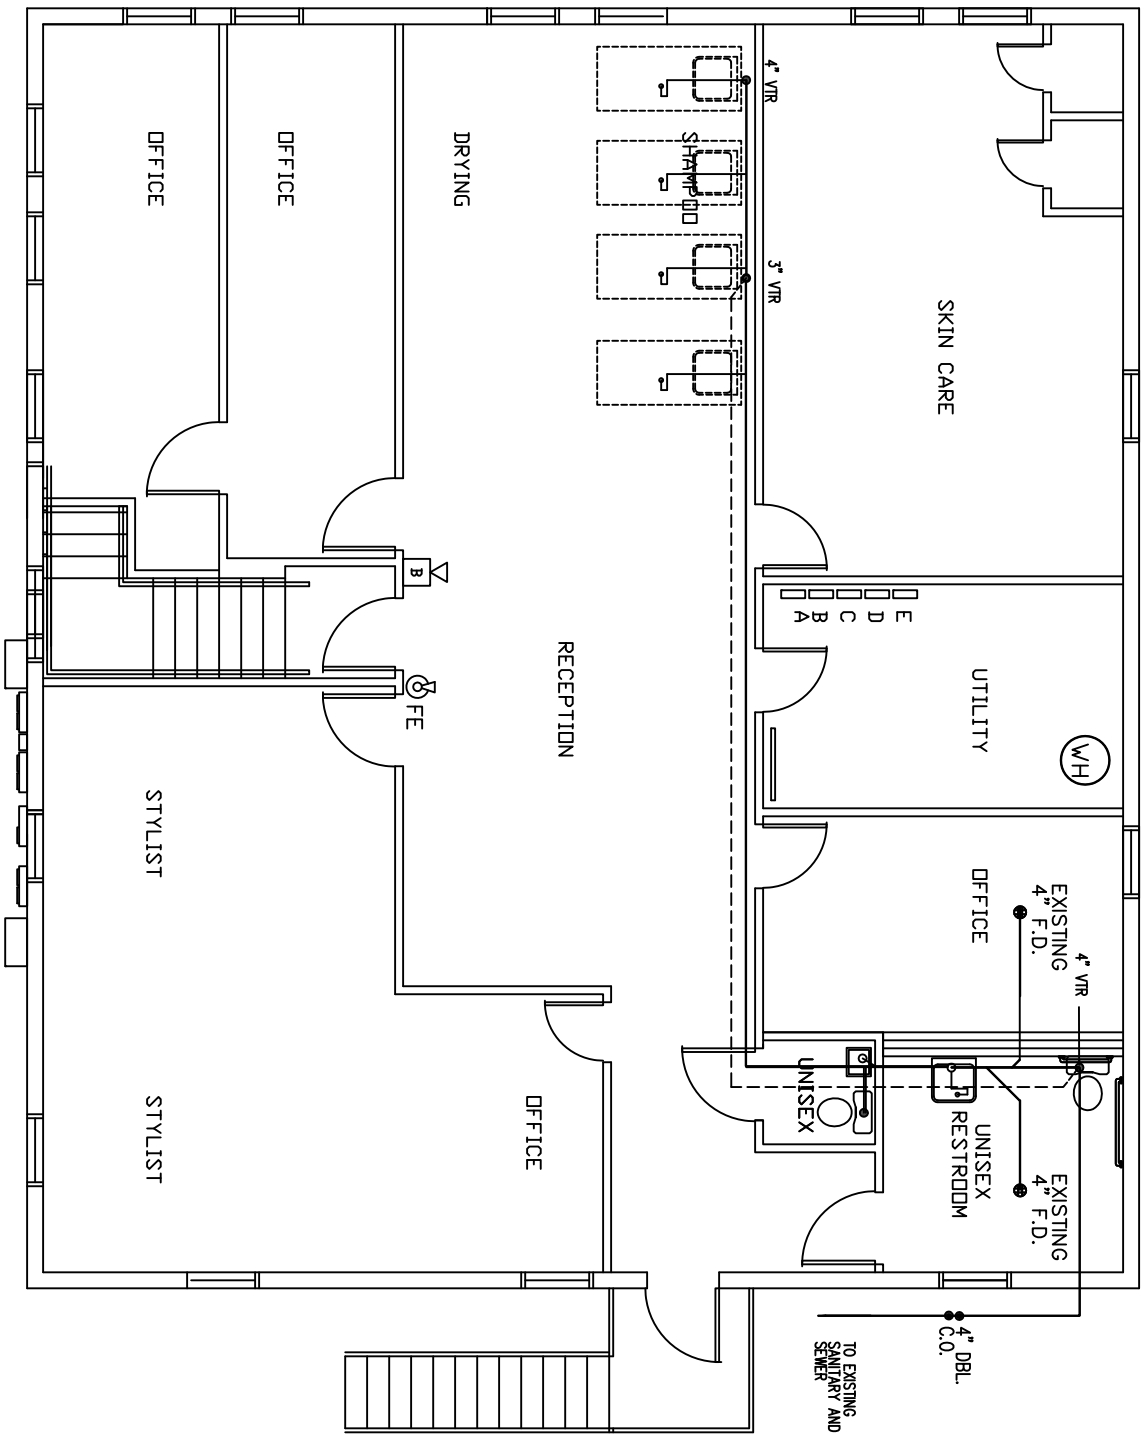

SECOND FLOOR
PLUMBING PLAN
SCALE: 1/8" = 1'-0"





PLUMBING NOTES

UNLESS OTHERWISE NOTED,
ALL WATER LINES TO BE INSULATED ABOVE AND BELOW GRADE.
ALL WATER SUPPLY LINES TO BE 3/4" DIA. COPPER W/ 1/2" DIA. STUBS AND SHUT OFF VALVES AT EACH FIXTURE.

WASTE, SOIL AND VENT RISER DIA.

NOTE: VERIFY ALL FIXTURE AND PIPE SIZE WITH PLANS N.T.S.

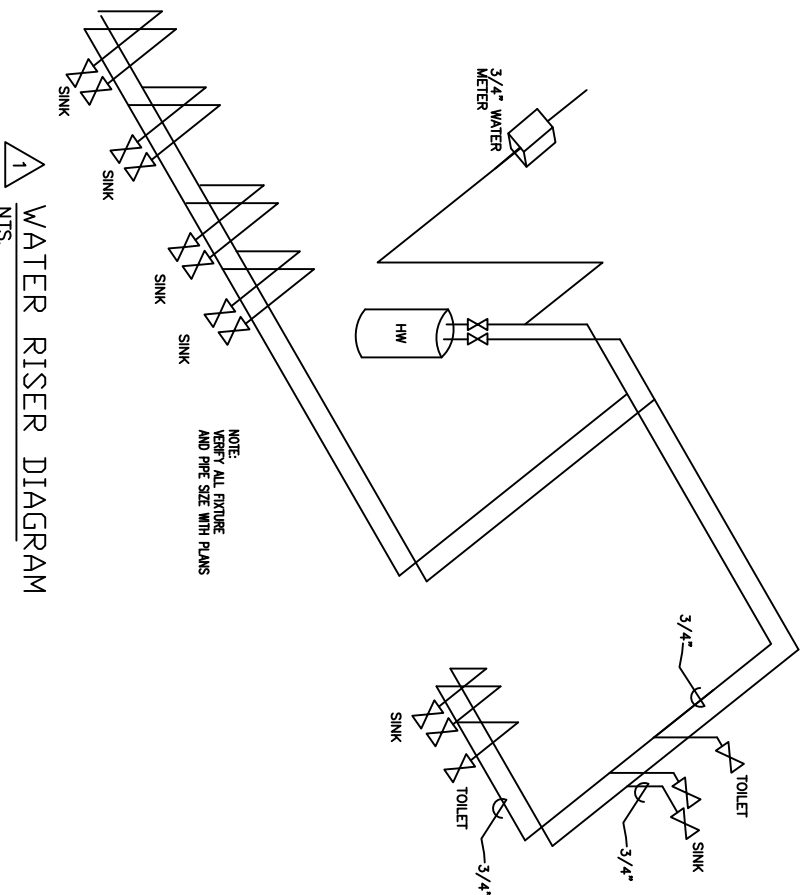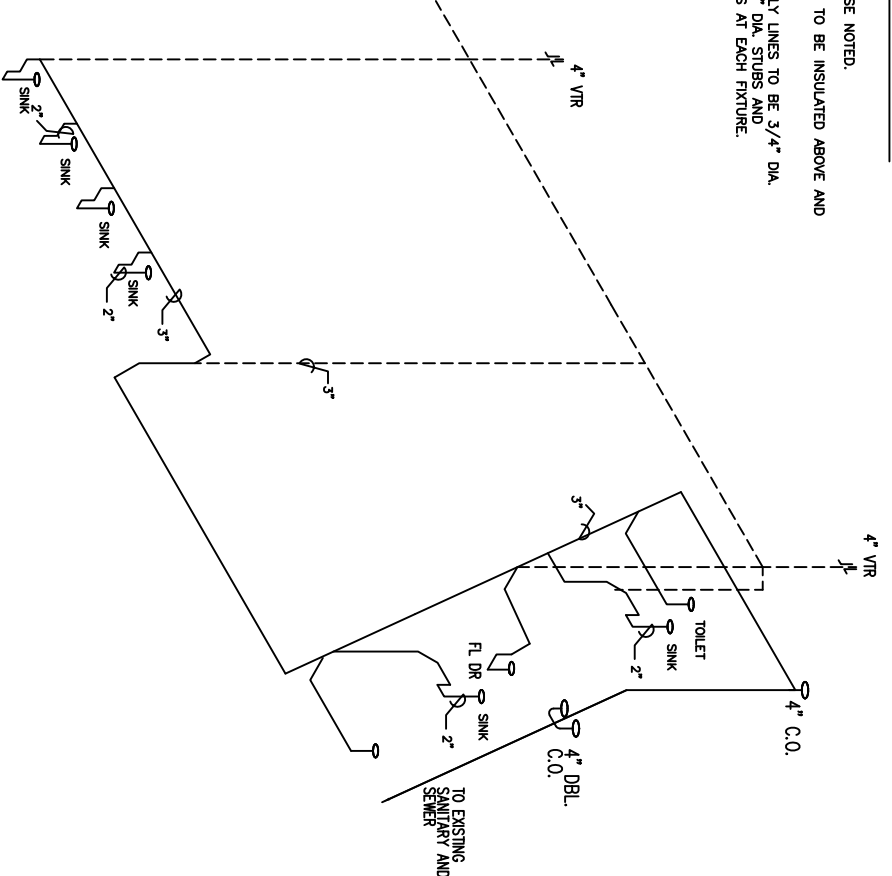

WATER RISER DIAGRAM

NOTE: VERIFY ALL FIXTURE AND PIPE SIZE WITH PLANS

PRJ #:	PRJHAIR
DATE:	1/15/18
REVISION:	4/25/18
DRAWN BY:	JE
REVIEWED BY:	JE
SCALE:	

QUEENS OF EGYPT
PLUMBING & MECHANICAL PLAN
313 NORTH MACOMB STREET
TALLAHASSEE FLORIDA



JIM ERVIN...
ARCHITECTURAL DESIGN SERVICE
6279 WHITTONDALE DR
TALLAHASSEE, FL 32312
(850) 274-2321
FL. ARC. # 0011528

DRAWING NO.
P 1
5 OF 5 DWGS.