



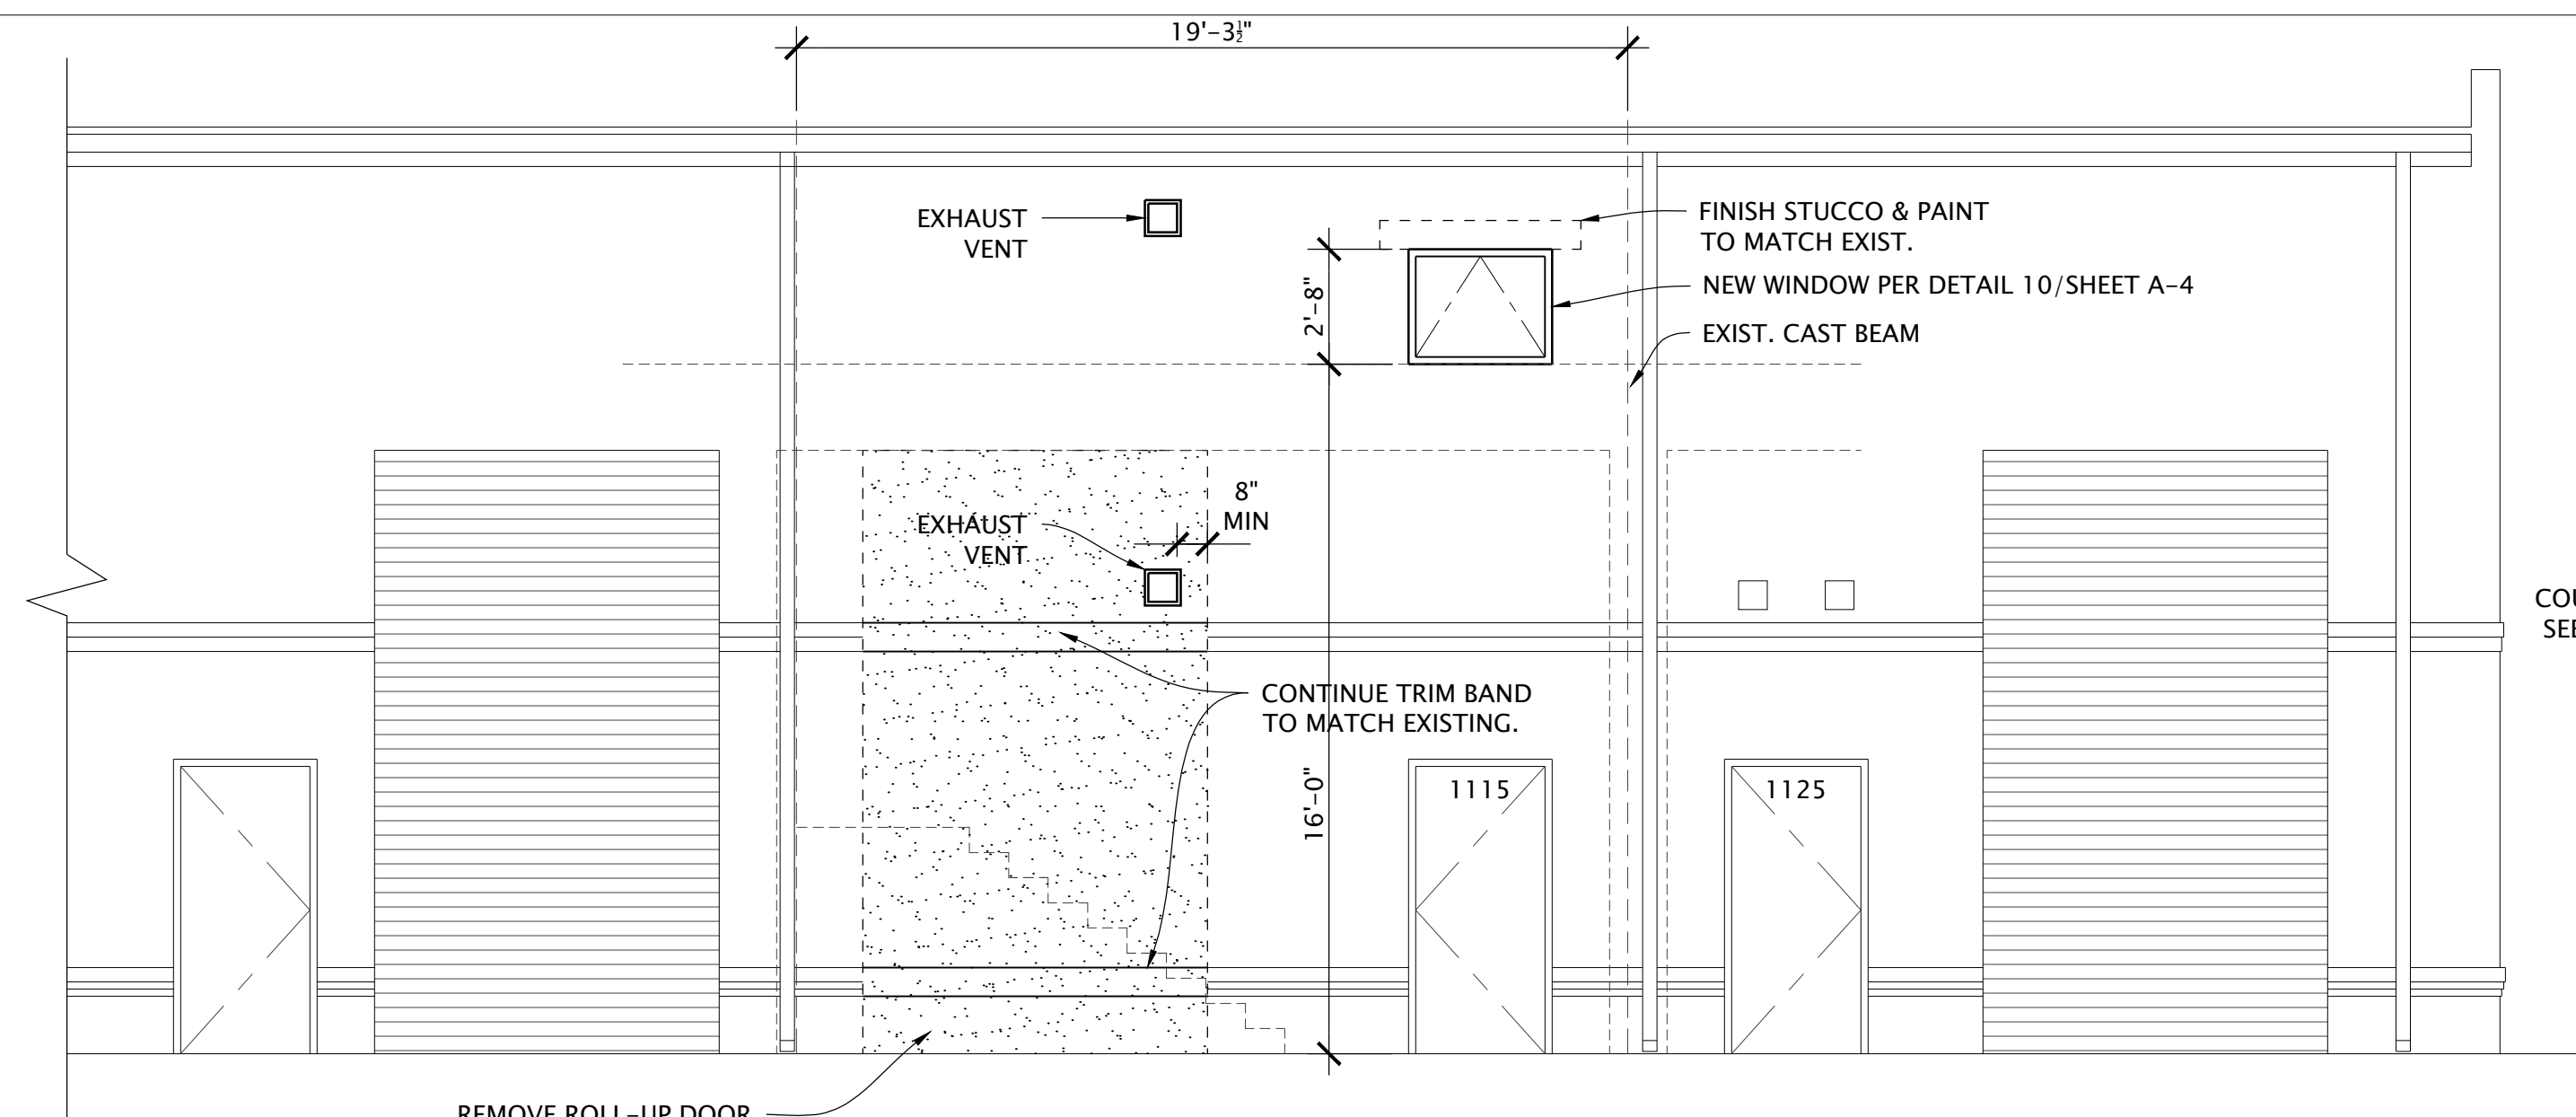

3 NORTH ELEVATION  
SCALE: 1/4" = 1'-0"

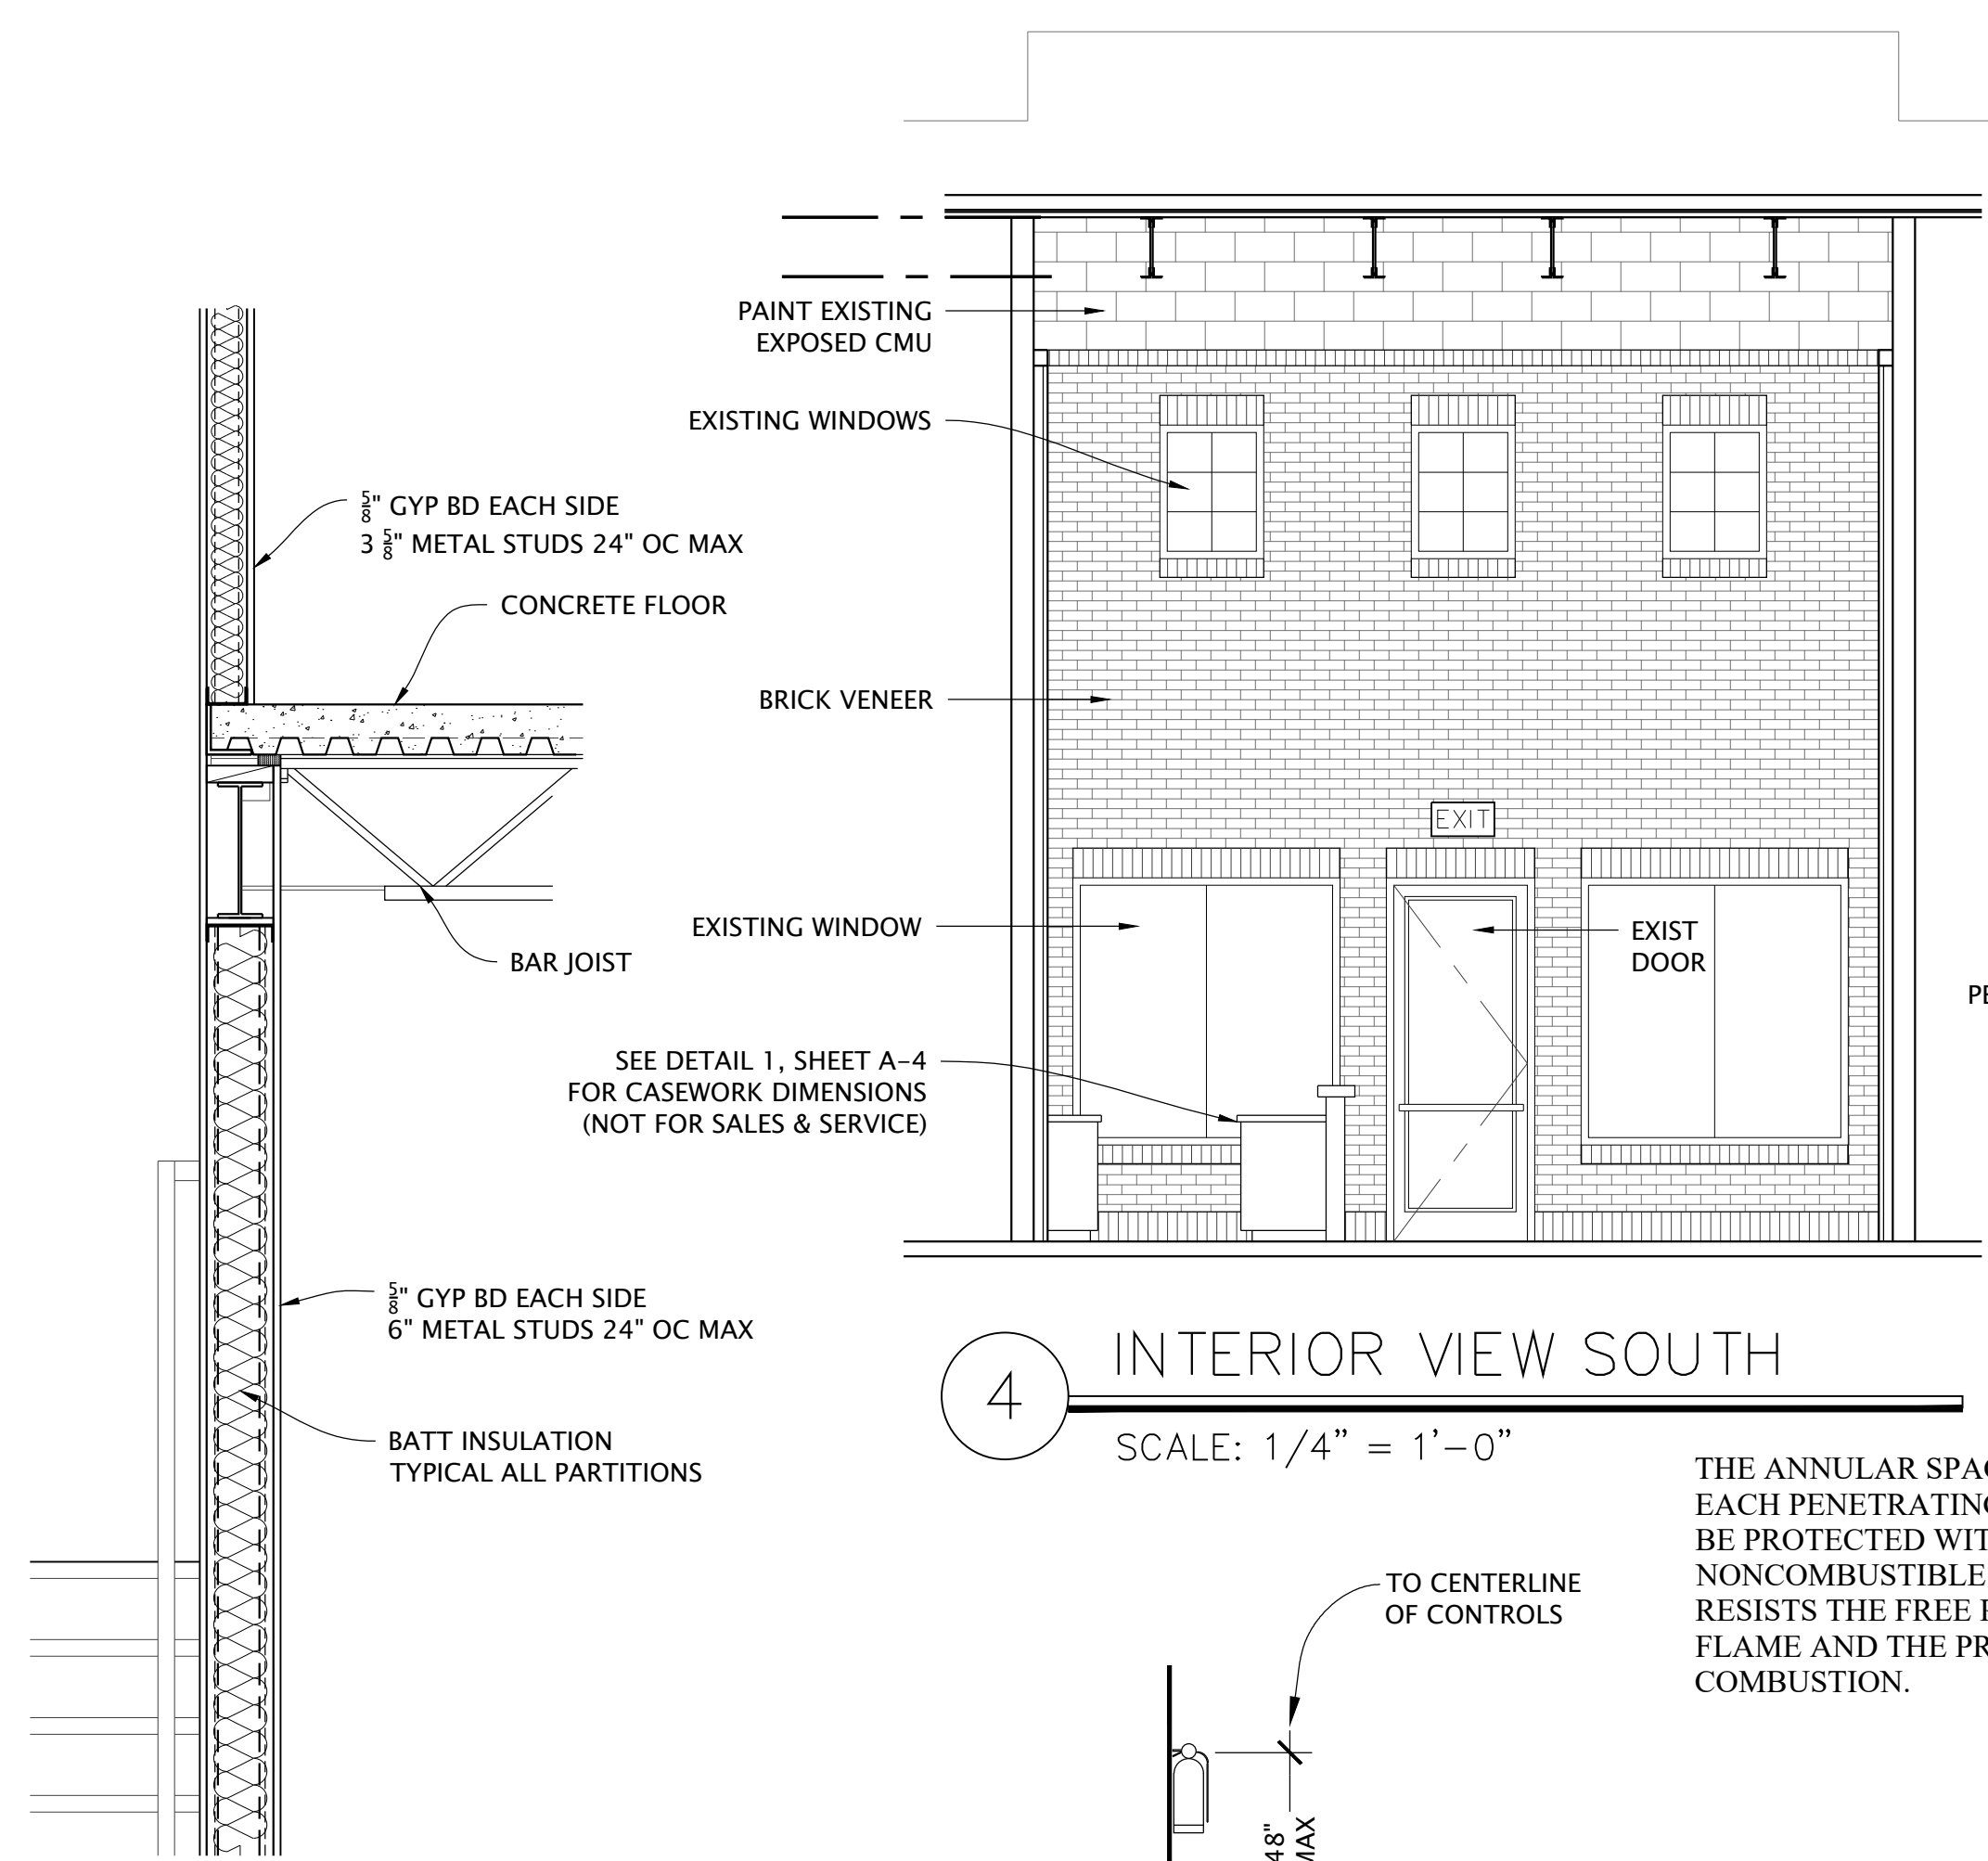


4 INTERIOR VIEW SOUTH  
SCALE: 1/4" = 1'-0"

5 WALL SECTION  
SCALE: 3/4" = 1'-0"


F FIRE EXTINGUISHER  
SCALE: NTS

PORTABLE FIRE EXTINGUISHER:  
2A-10BC PORTABLE FIRE EXTINGUISHER  
SUBCLASS B REFERENCE NFPA 10.

75 FT MAX. TRAVEL DISTANCE REFER TO FLOOR PLANS FOR  
RECOMMENDED LOCATIONS.

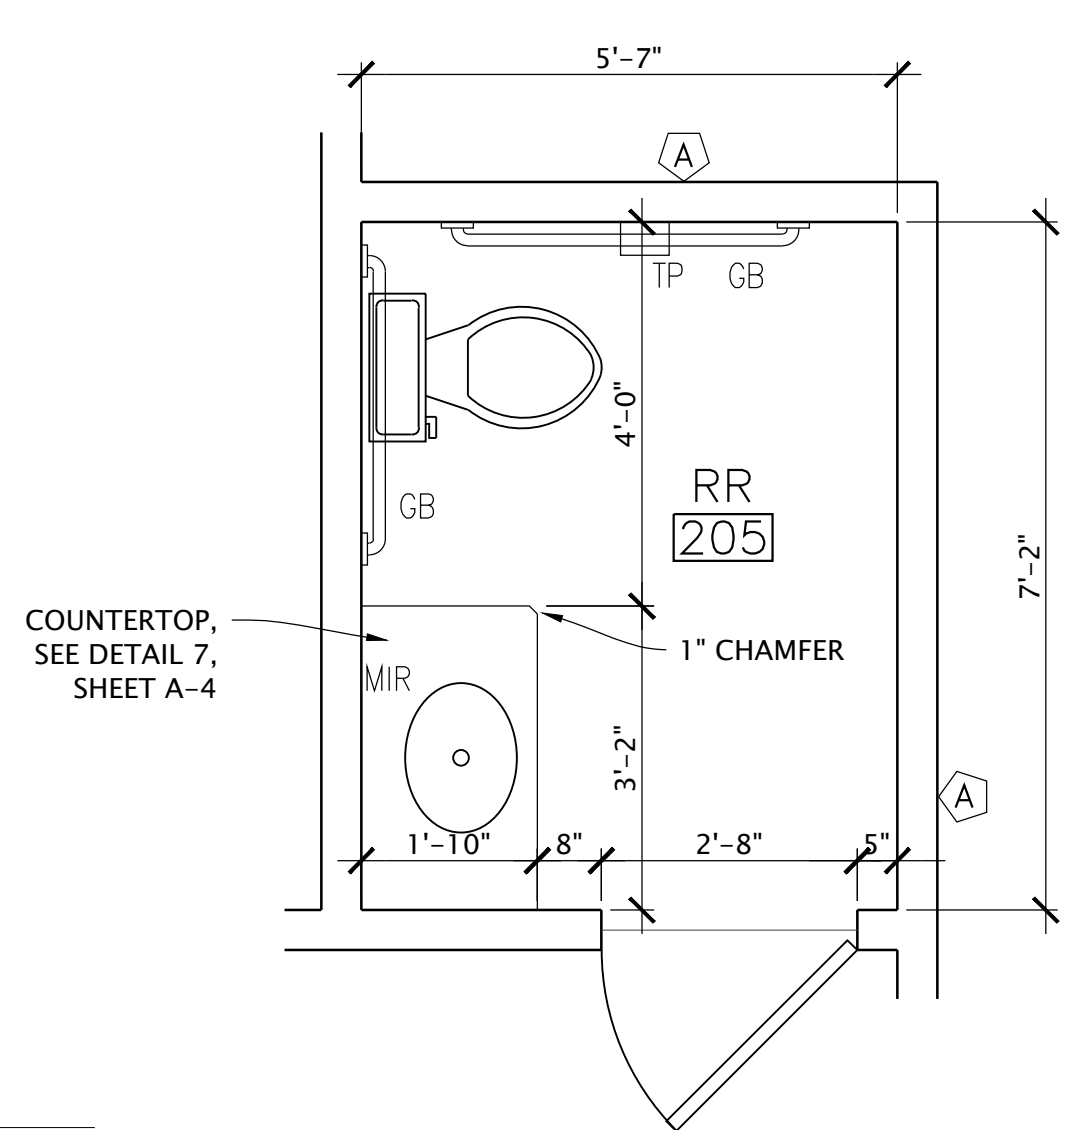


2 ENLARGED PLAN DETAIL  
SCALE: 1/2" = 1'-0"

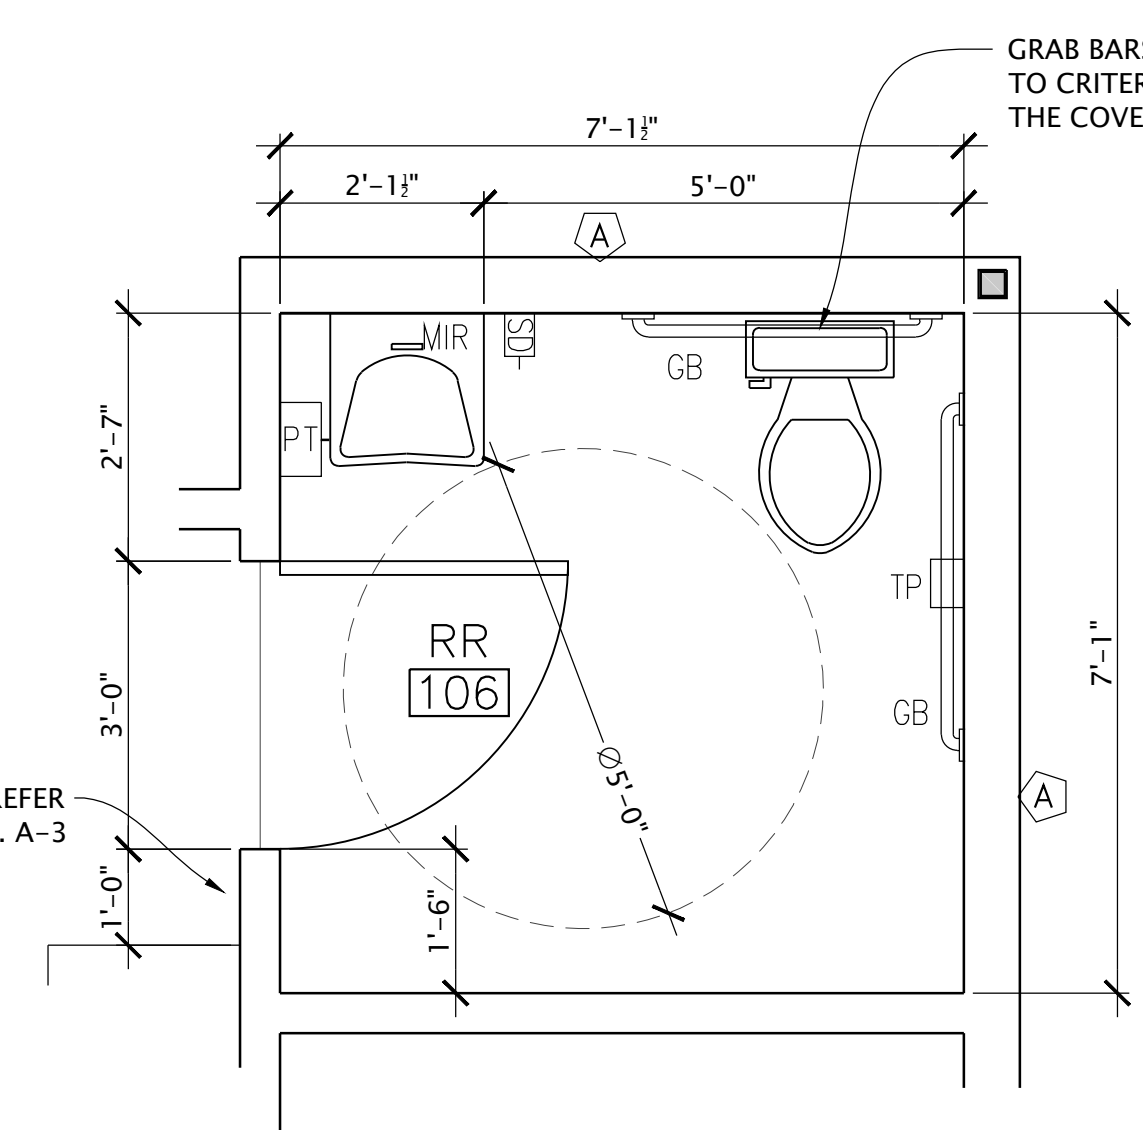


1 ENLARGED PLAN DETAIL  
SCALE: 1/2" = 1'-0"

- ACCESSORIES:
- GB 1-1/2" DIAMETER STAINLESS STEEL GRAB BAR. WALL MOUNTED PROVIDE SUPPORT BLOCKING IN WALL FOR SECURE MOUNT TO WITHSTAND MINIMUM 300 POUND POINT LOAD.
  - MIR WALL MOUNTED MIRROR WITH CHROME EDGE BAND. CENTER ABOVE SINK.
  - PT PAPER TOWEL DISPENSER WALL MOUNTED. STUB CONDUIT FOR FUTURE ELECTRIC HAND DRYER OPTIONAL - COORDINATE WITH THE OWNER.
  - PTR KITCHEN ROLL PAPER TOWEL HOLDER
  - SD SANITARY NAPKIN DISPOSAL
  - TP TOILET PAPER DISPENSER

FEB 20, 2019  
OCT 19, 2018  
DATE ISSUED  
CMC  
DRAWN BY

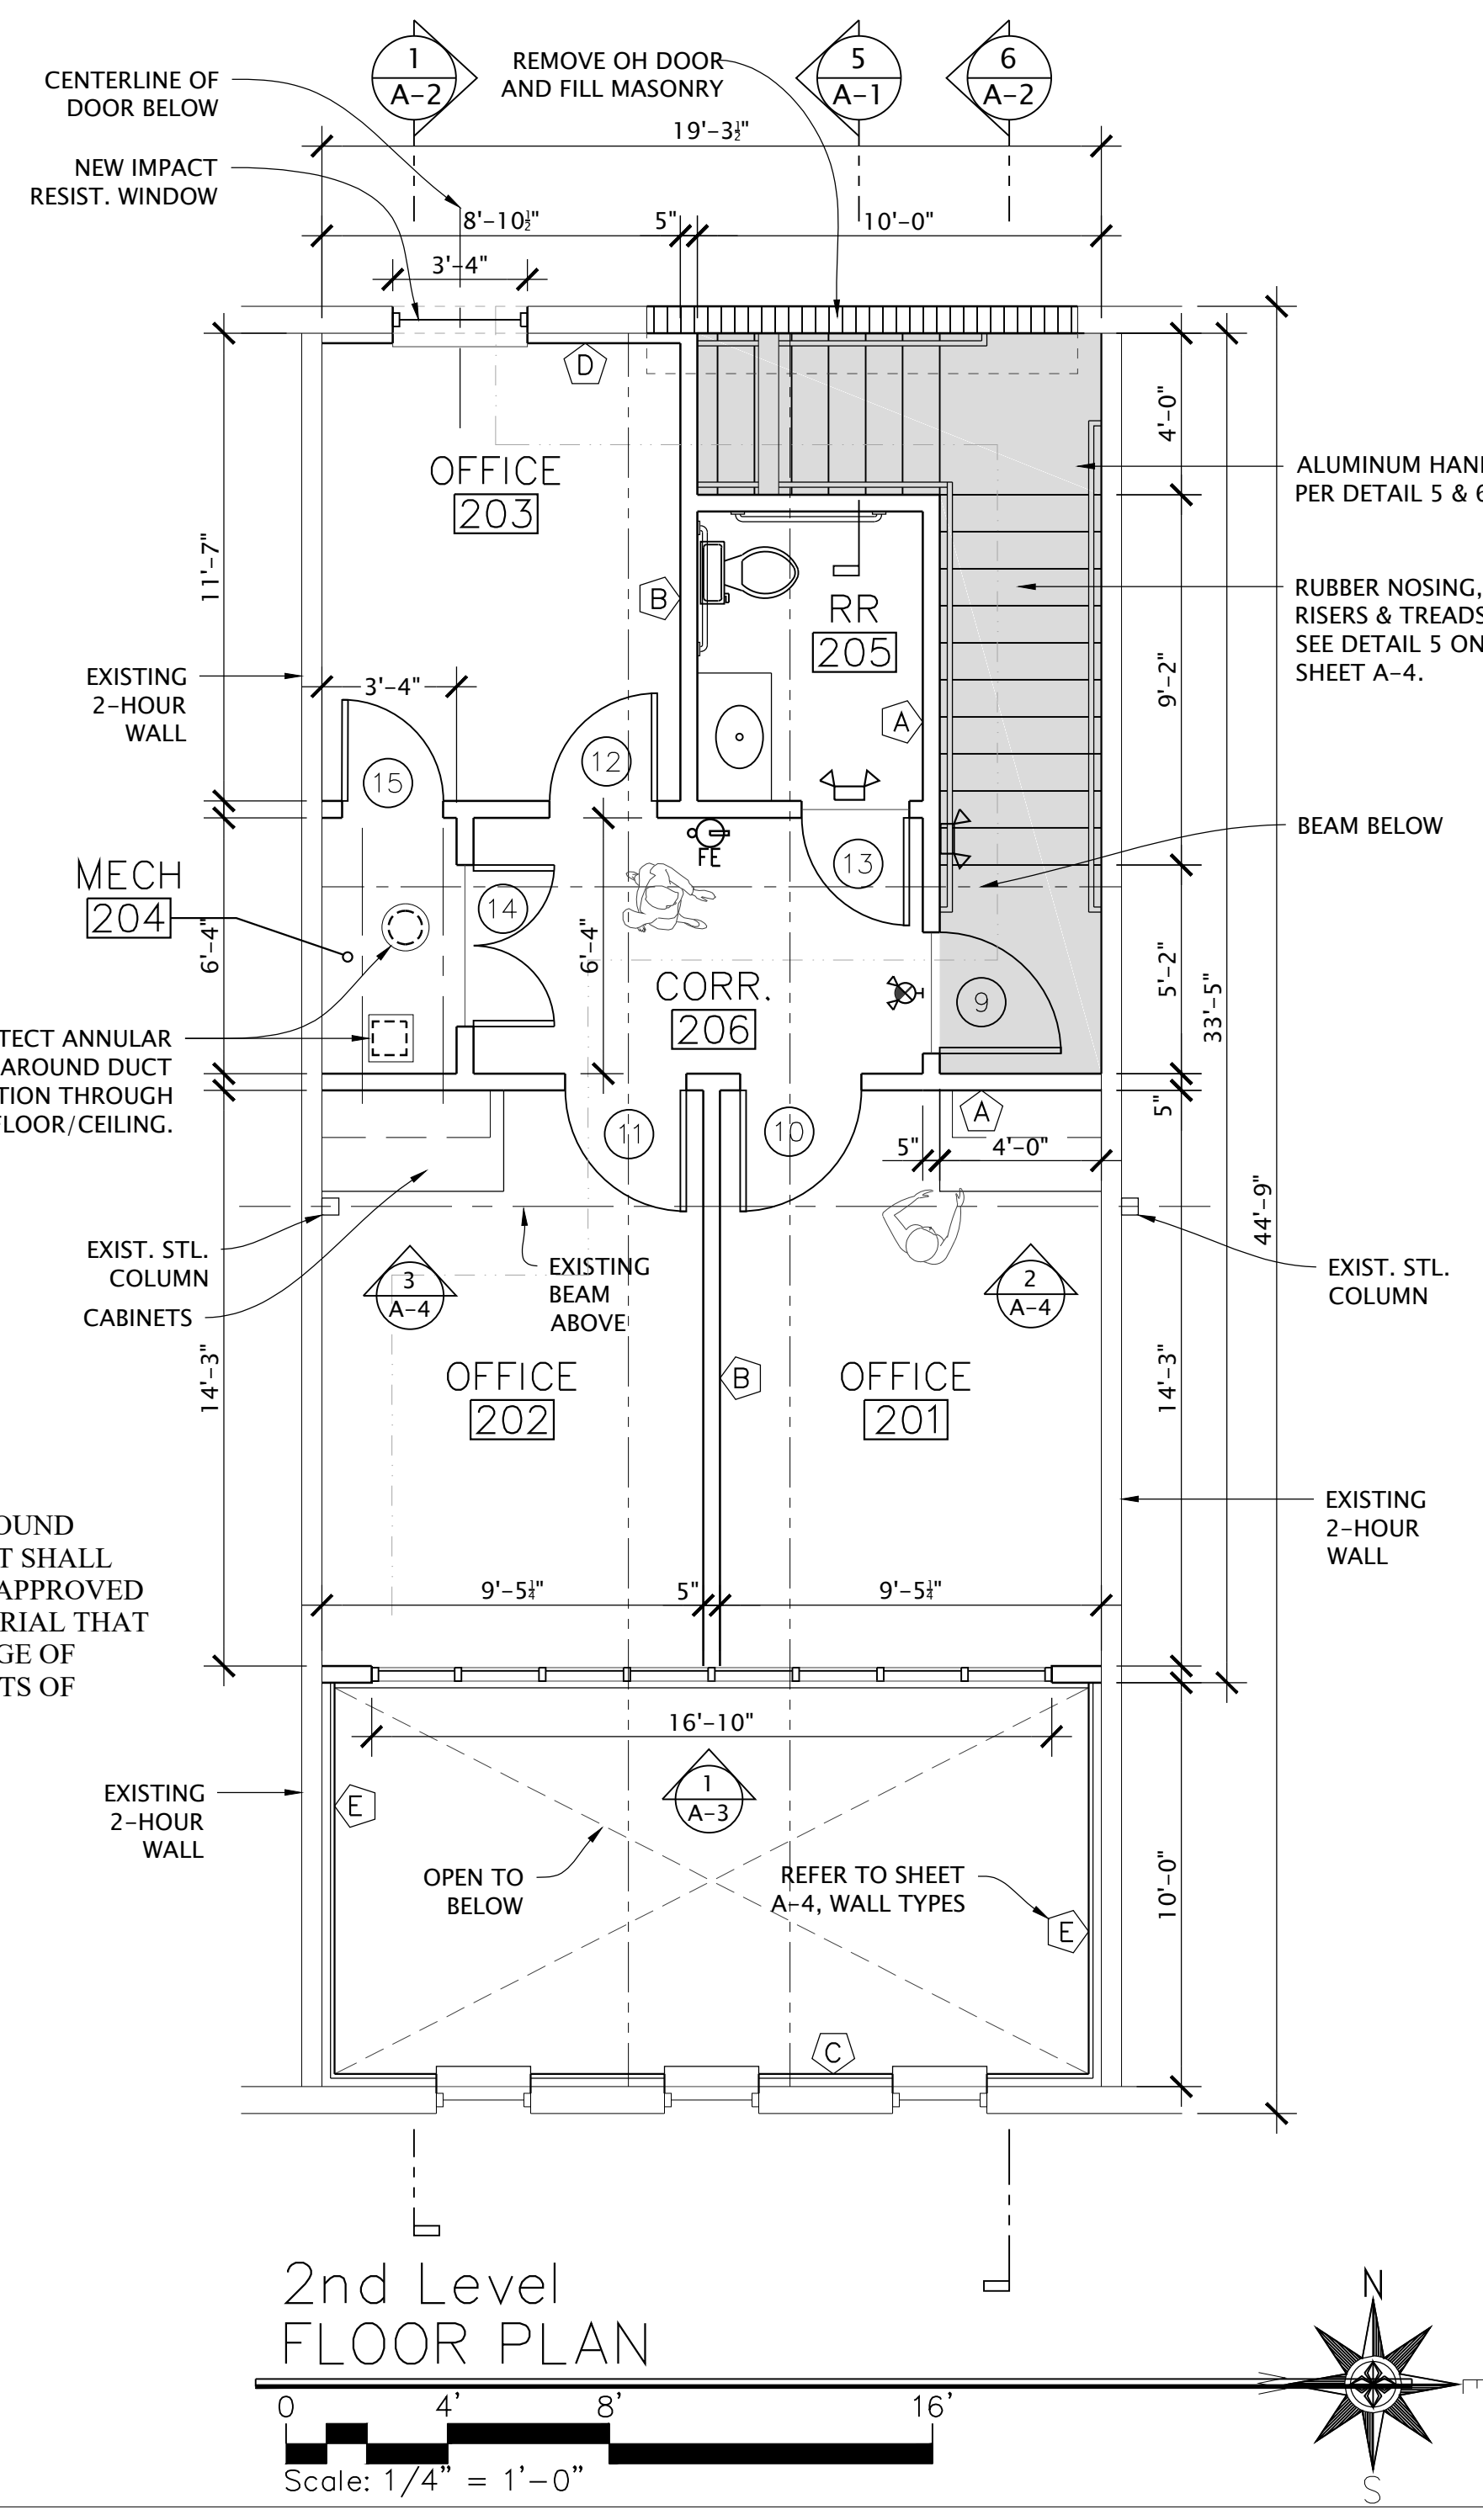

2nd Level  
FLOOR PLAN

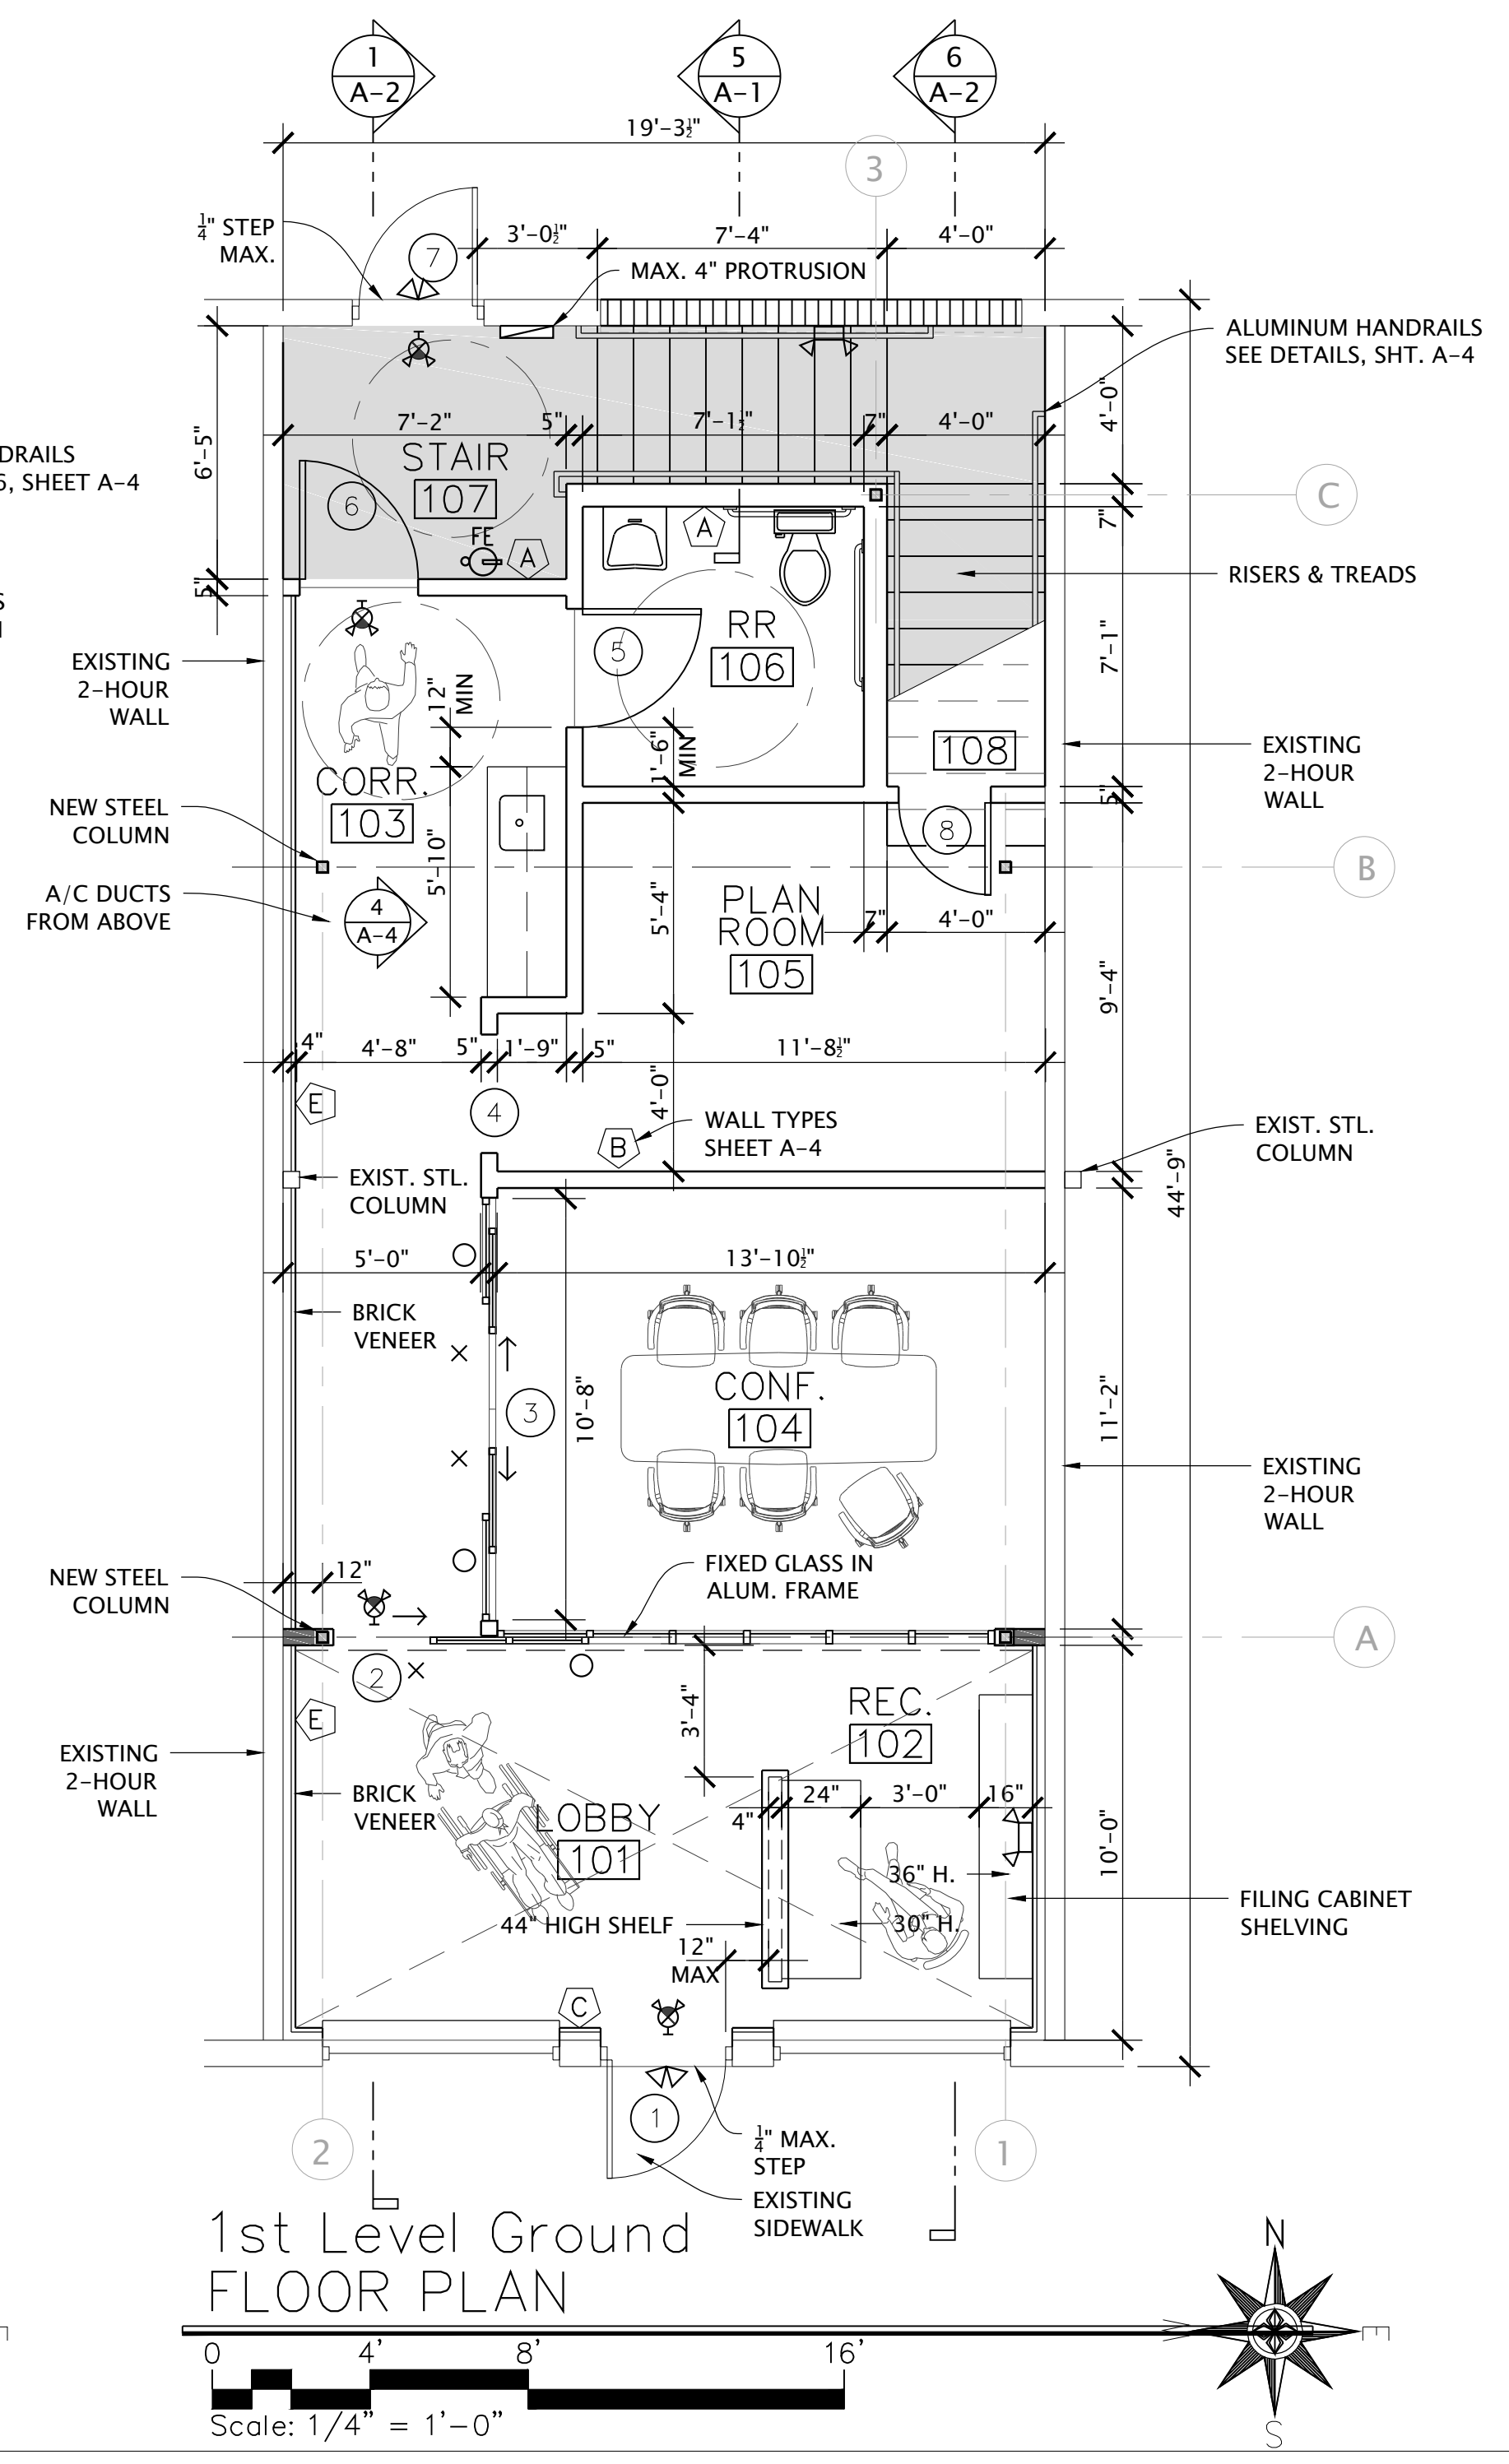

1st Level Ground  
FLOOR PLAN



C.M.CRAWFORD ARCHITECT, INC.  
FL #AA26001812  
-CMCARC-  
P.O. BOX 6511 VERO BEACH, FLORIDA 32961  
PH 772.567.1212 CMCARC@MSN.COM

CONTRACTOR TRADES  
INTERIOR ALTERATION

1115 22nd Street  
Vero Beach Florida

PLANS

SHEET TITLE

A-1

SHEET NUMBER