


Seal:

JAVIER BEJARANO, P.E.
FLORIDA P.E. LIC. # 63830

Location:

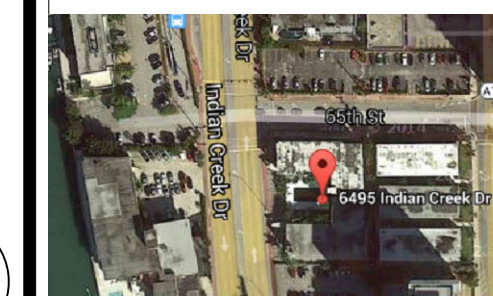

PROJECT No. 14-110

INTERIOR
BUILDING
REMODELING

RESIDENCE
OCCUPANCY

Address:

6495 Indian Creek
Miami FL, 33141

Contents:

GROUND
FLOOR PLAN

Date Issued: June 9, 2014

Date: June 9, 2014

Drawn by: J.C.



Checked By: J.C.

Revisions


No.	Date	Description
1	06/16/2014	Building Comments
2	09/15/2014	Building Comments
3	10/05/2014	Building Comments

Sheet

A-1.1

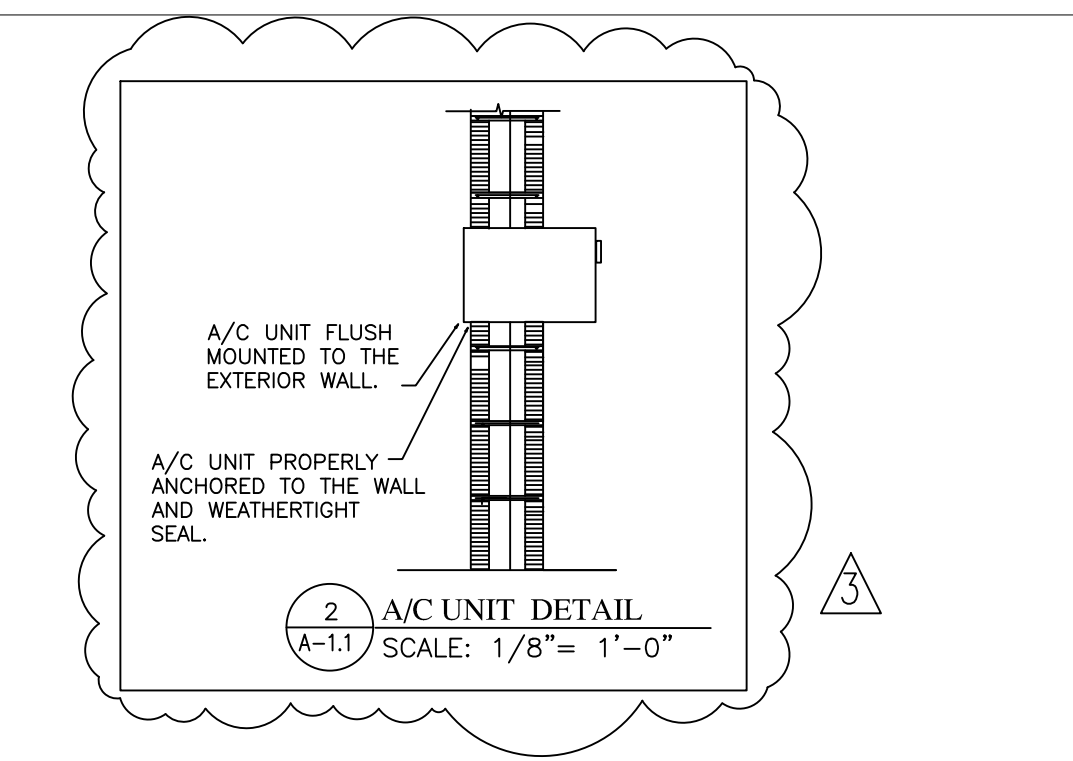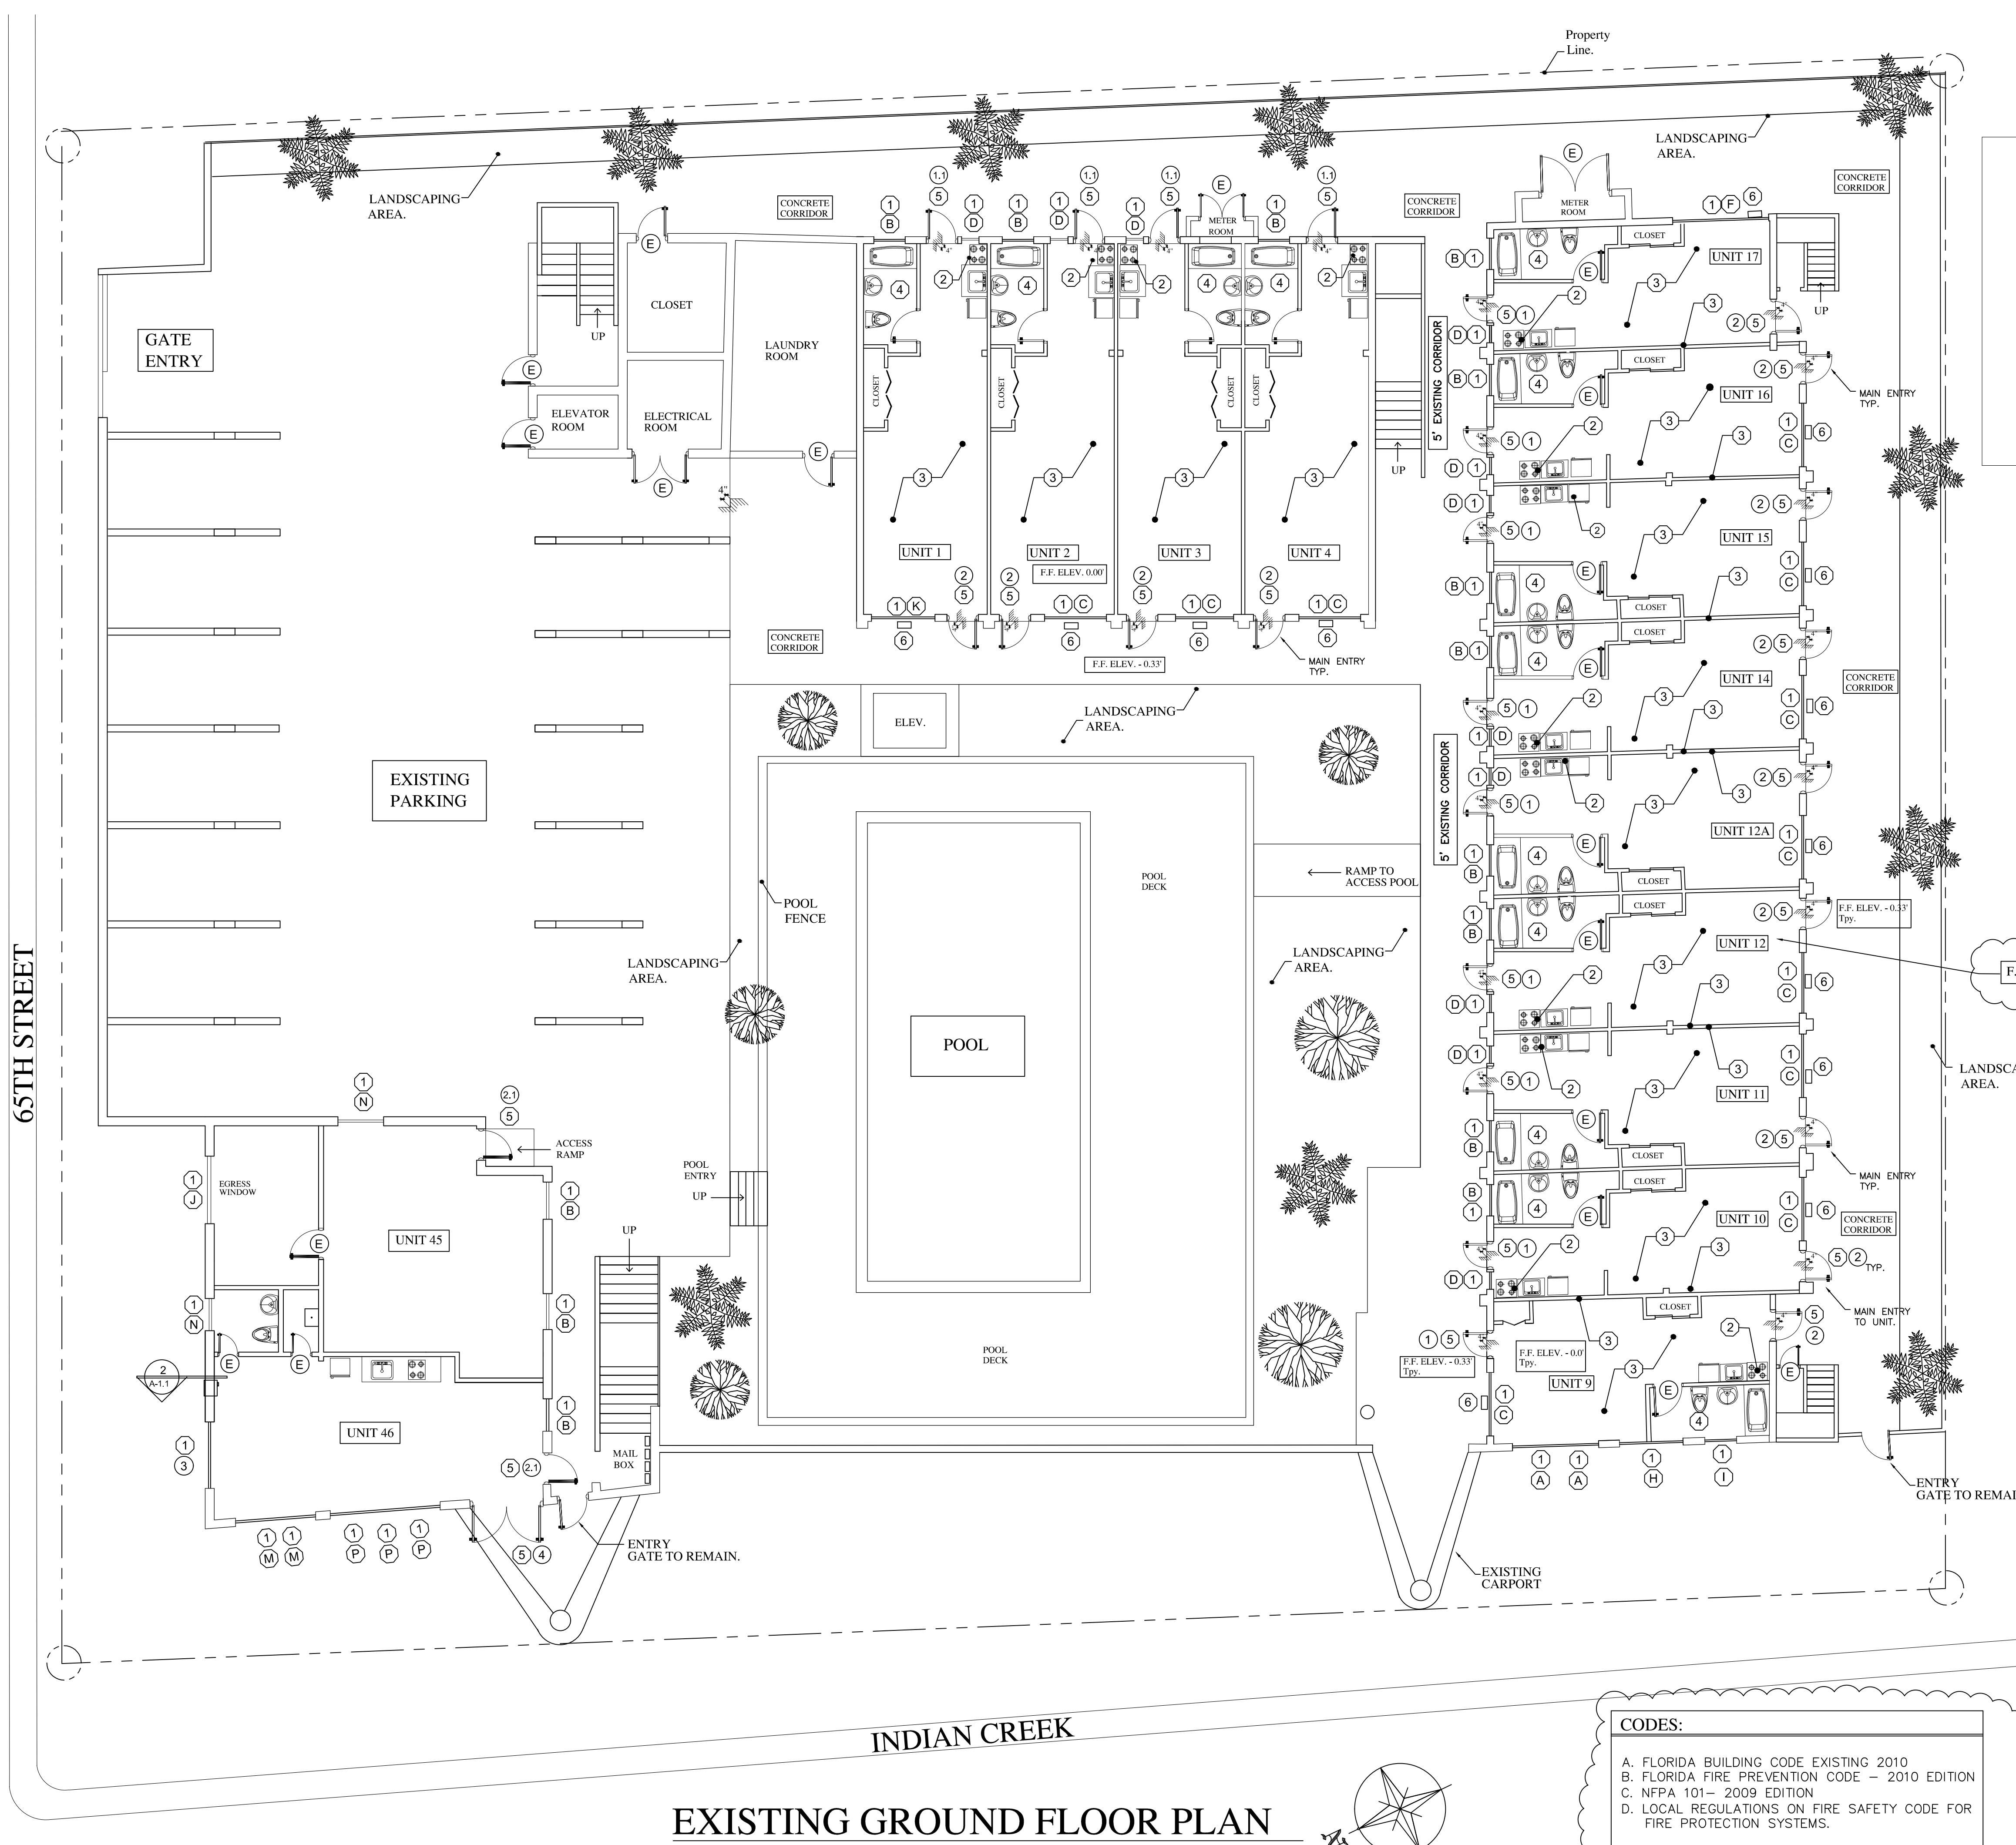

Notes:
REFER TO SHEET A-1.1 FOR
INTERIOR SCOPE OF WORK
REQUIRED AT UNITS.

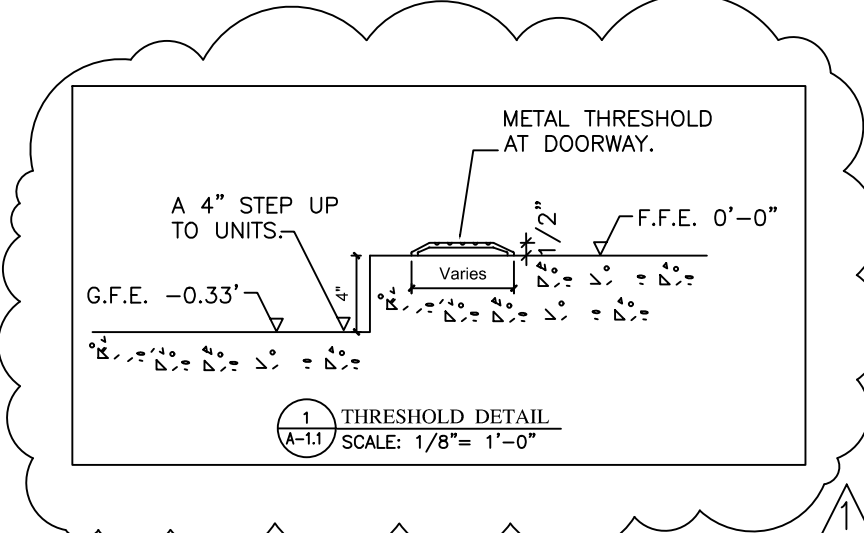

Sprinkles System:
THIS BUILDING DOES NOT HAVE
SPRINKLER SYSTEM.

NOTES:
SEE STRUCTURAL SCOPE OF WORK IN STRUCTURAL
SHEETS S-1.0. AS PER FBC 2010 SECTION 107.2.1.

CODES:
A. FLORIDA BUILDING CODE EXISTING 2010
B. FLORIDA FIRE PREVENTION CODE - 2010 EDITION
C. NFPA 101 - 2009 EDITION
D. LOCAL REGULATIONS ON FIRE SAFETY CODE FOR
FIRE PROTECTION SYSTEMS.

EXISTING GROUND FLOOR PLAN

SCALE: 1/8" = 1'-0"

