



NOTE: LIGHTING TO REMAIN AS IS.
NOTE: CIRCUITS LABELED AS EXISTING ARE TO BE LEGALIZED AND CIRCUITS LABELED AS NEW ARE TO BE INSTALLED.

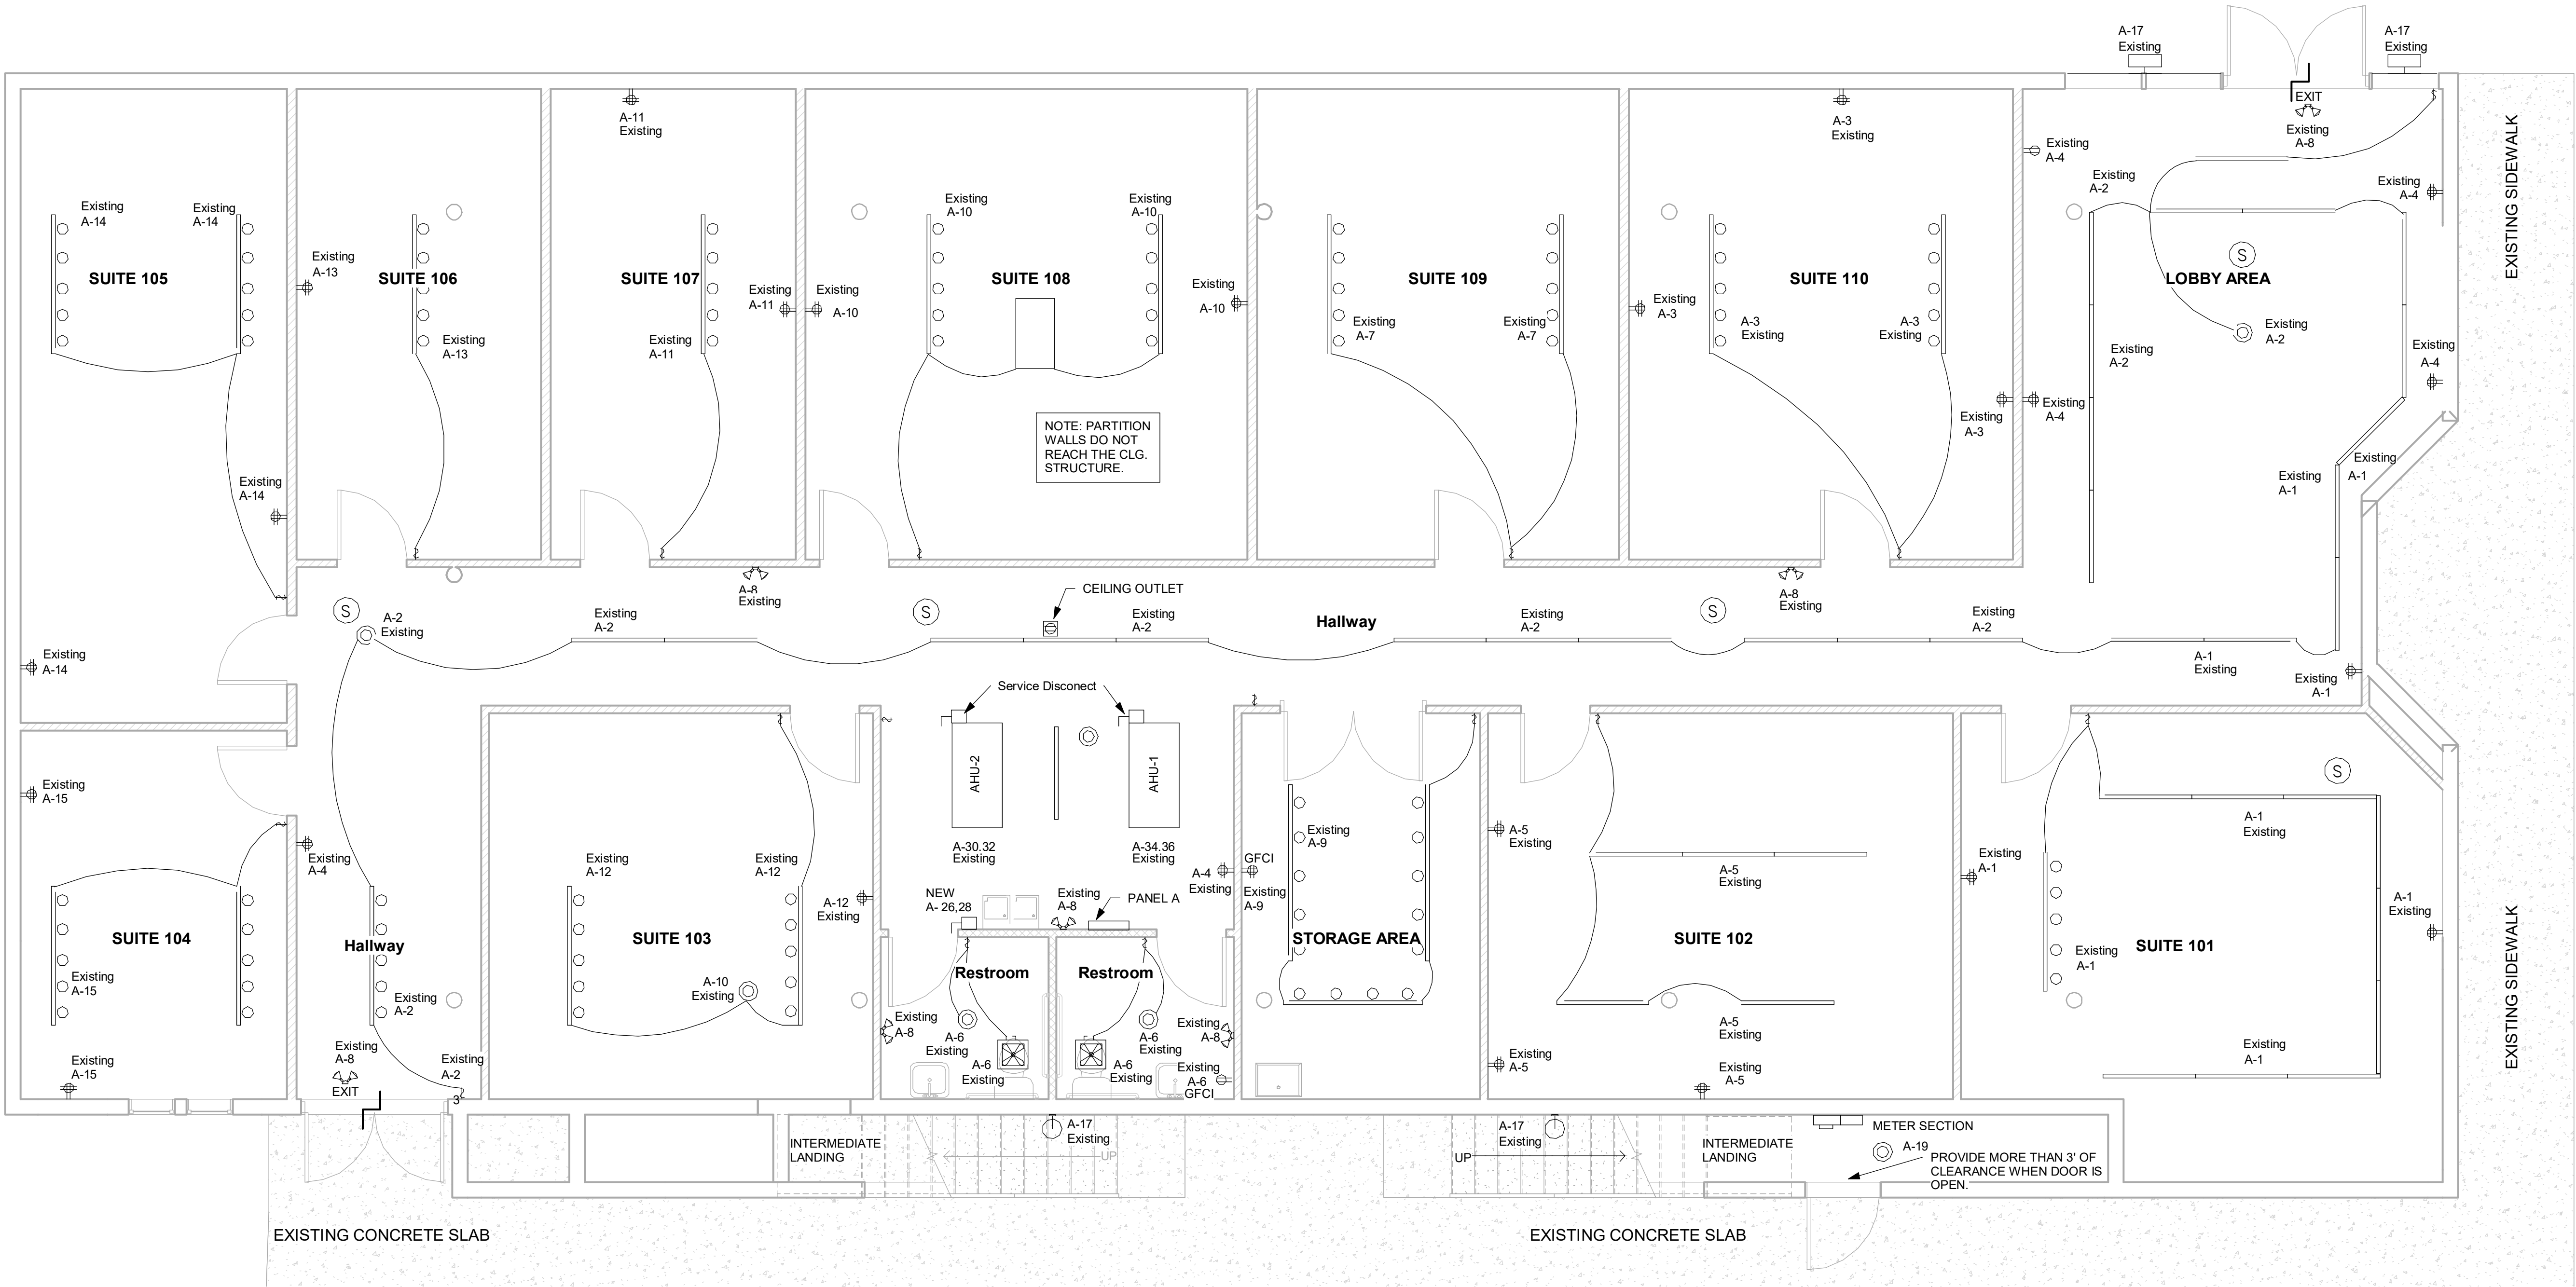


1 1st Floor Proposed Electrical Plan
1/4" = 1'-0"

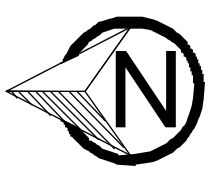

Scope & Reference:
Legalization/Remodeling & Repair
#BB2019008085

Department Seal:

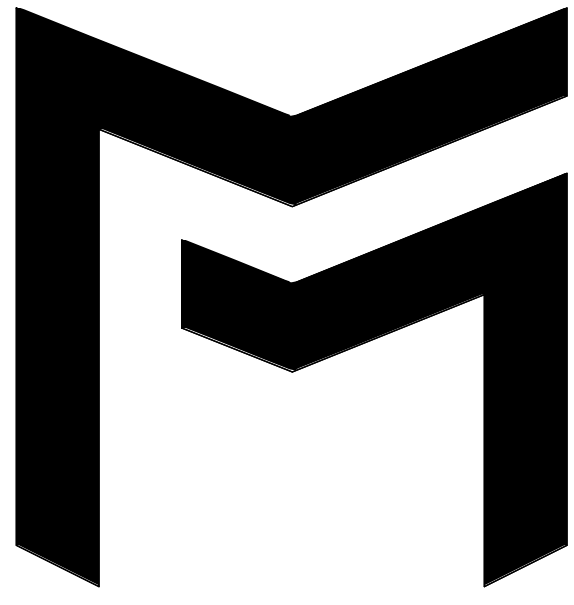

MEC DESIGN

6187 NW 167 ST #H24 MIAMI FL 33015
OFFICE: (305) 356-1755
WWW.MECDESIGNMIAMI.COM
ID0001355/IB0000591
AR0007205/PE31509
HOMERO CRUZ, L.I.D.
MANUEL A. VEGA, A.R.
JOSE A. MARTINEZ, P.E.

THIS DRAWING CONTAINS PROPRIETARY INFORMATION AND IS THE PROPERTY OF "MEC DESIGN CONSULTANTS, INC" AND MAY NOT BE REPRODUCED OR DISTRIBUTED WITHOUT THE WRITTEN PERMISSION OF "MEC DESIGN CONSULTANTS, INC"

Client Name:
5900 W LITTLE HAITI LLC

Project name/address:
Office Building
185 NE 59 ST
Miami, FL 33137

Seal:

Revision Schedule

Revision	Date	By
2	12/12/2024	JL

Drawn by:
JL

Checked by:
HC

Date:
03/24/2023

Sheet name:
1st Floor Electrical Plan

Sheet number:
E102