



LUMINARIE SCHEDULE

Symbol	Count	Manufacturer	Model #	Volt	Watt	Lumens	Color Temperature	Notes
⊙	19	Volume Lighting	V2128-5	120	17	1400	3000	
⊘	1	HALO	HLBSL6099FS351EMWR	120	12.5	915	3000	6 in

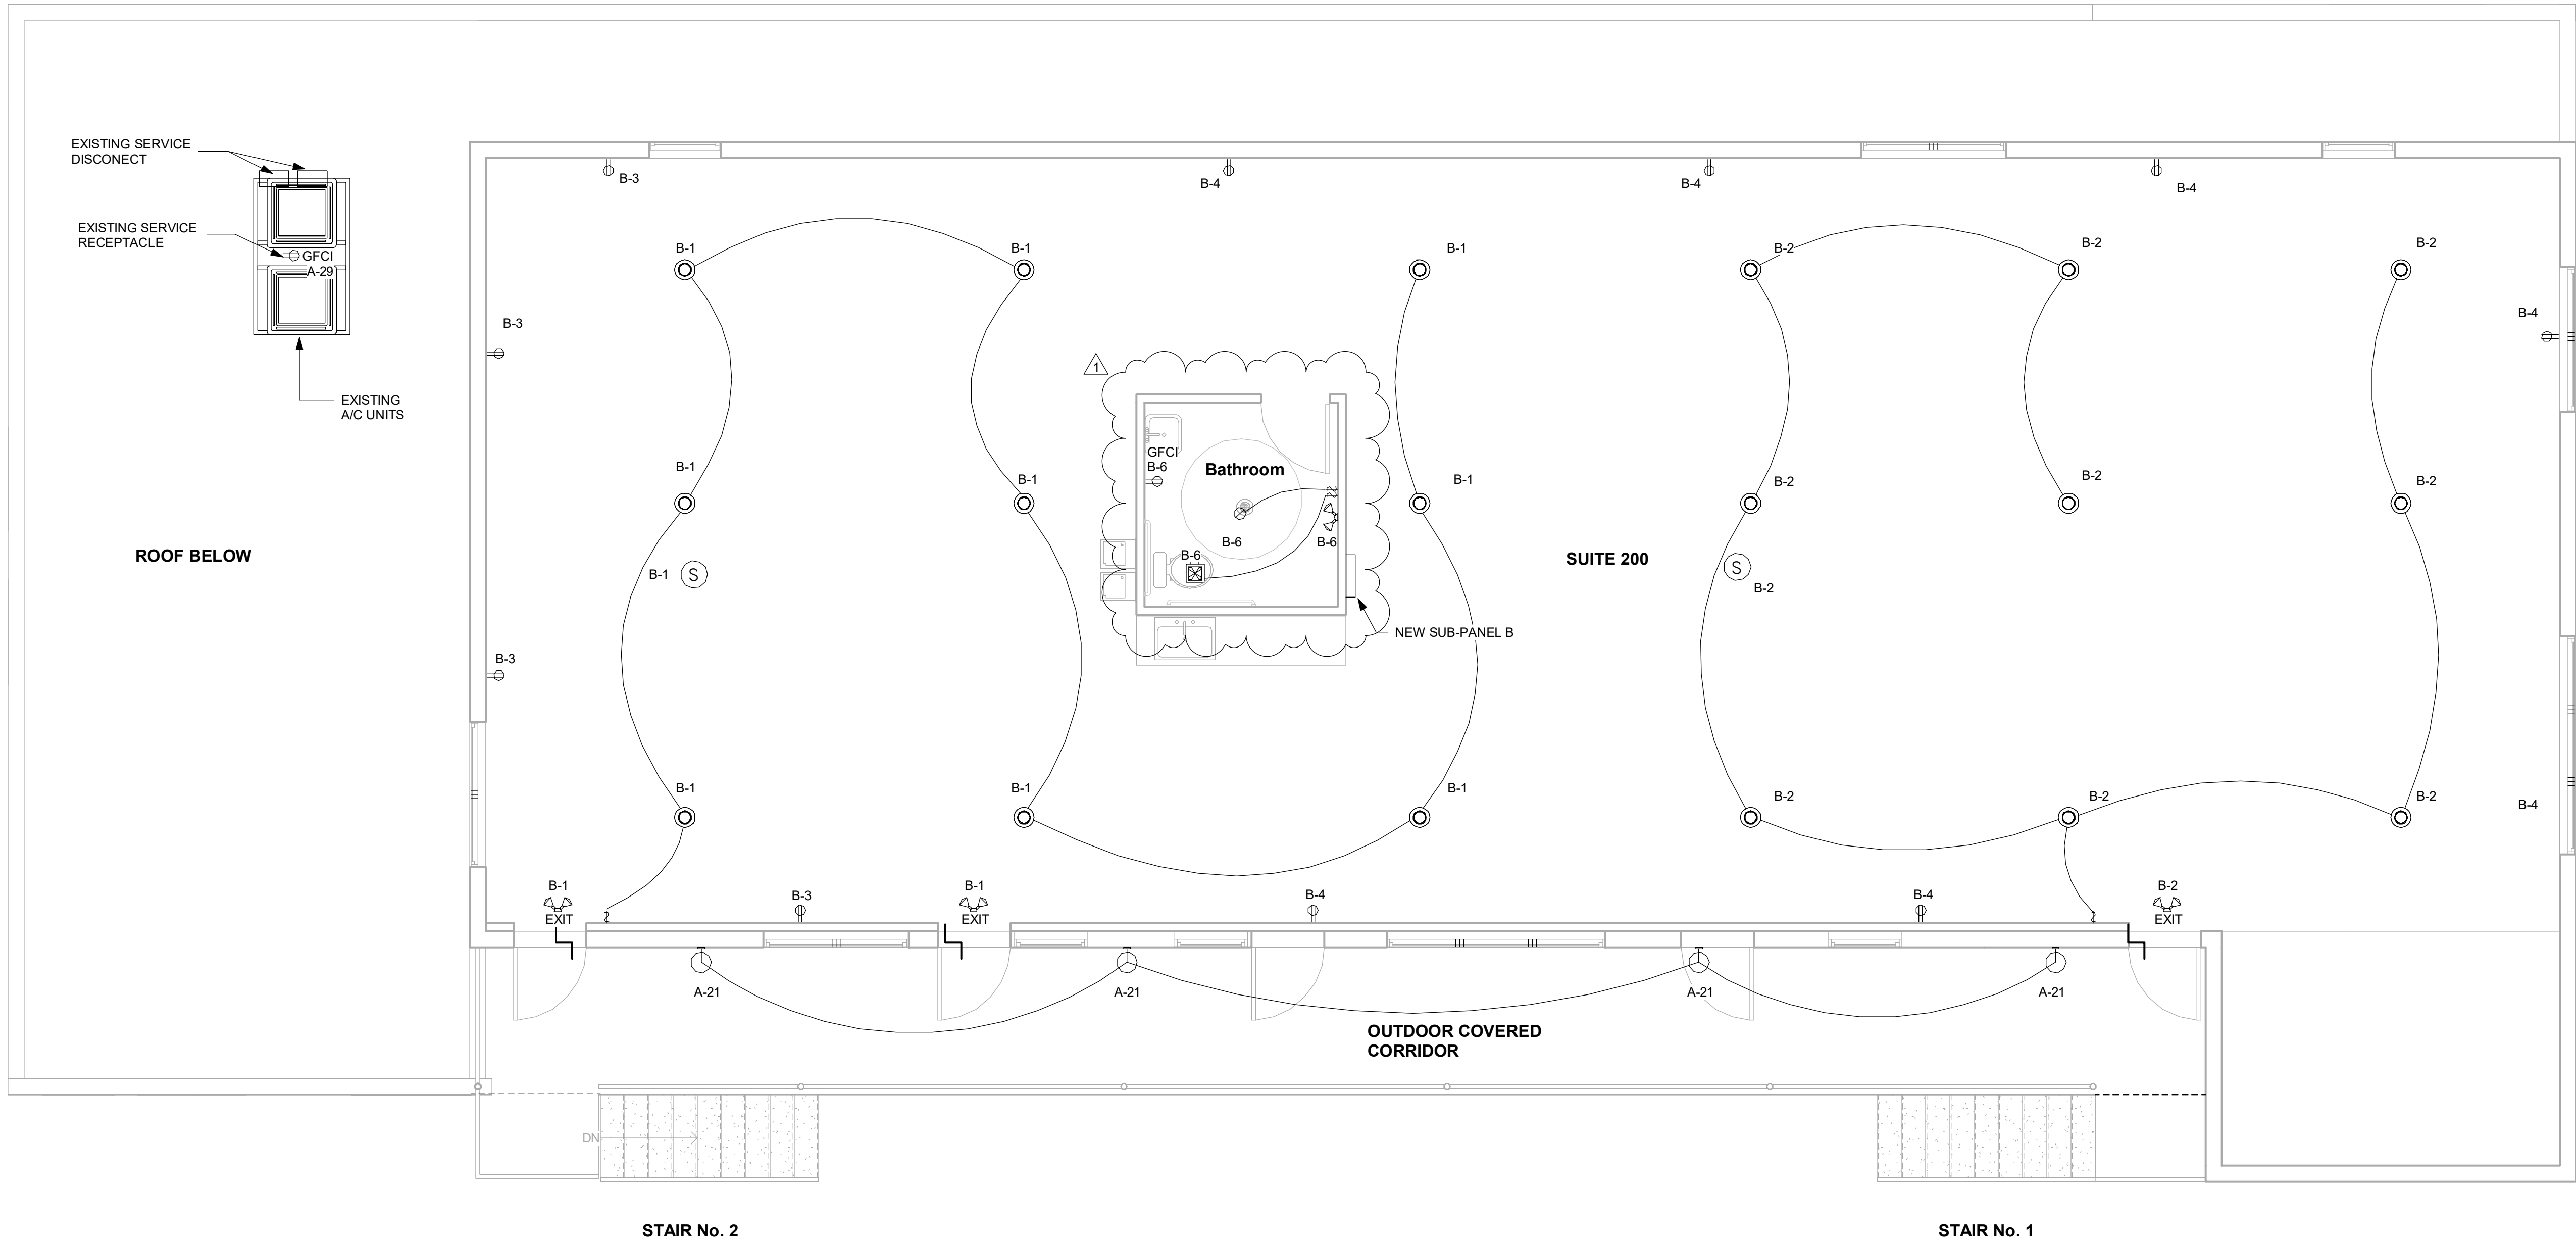

① 2nd Floor Electrical Plan
1/4" = 1'-0"

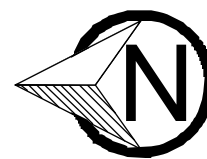

Scope & Reference:

Legalization/Remodeling &
Repair

#BB2019008085

Department Seal:



MEC DESIGN

6187 NW 167 ST #H24 MIAMI FL 33015
OFFICE: (305) 356-1755
WWW.MECDESIGNMIAMI.COM
ID0001355/IB0000591
AR0007205/PE31509
HOMERO CRUZ, L.I.D.
MANUEL A. VEGA, A.R.
JOSE A. MARTINEZ, P.E.

THIS DRAWING CONTAINS PROPRIETARY
INFORMATION AND IS THE PROPERTY OF
"MEC DESIGN CONSULTANTS, INC" AND MAY
NOT BE REPRODUCED OR DISTRIBUTED
WITHOUT THE WRITTEN PERMISSION OF
"MEC DESIGN CONSULTANTS, INC"

Client Name:
5900 W LITTLE HAITI LLC

Project name/address:
Office Building
185 NE 59 ST
Miami, FL 33137

Seal:

Revision Schedule

Revision	Date	By
1	02/29/2024	JL
2	12/12/2024	JL

Drawn by: JL

Checked by: HC

Date: 03/24/2023

Sheet name:
2nd Floor Electrical
Plan

Sheet number:
E103