


1 1ST FLOOR PLAN SANITARY
 SCALE: 1/8" = 1'-0"
 [North Arrow]

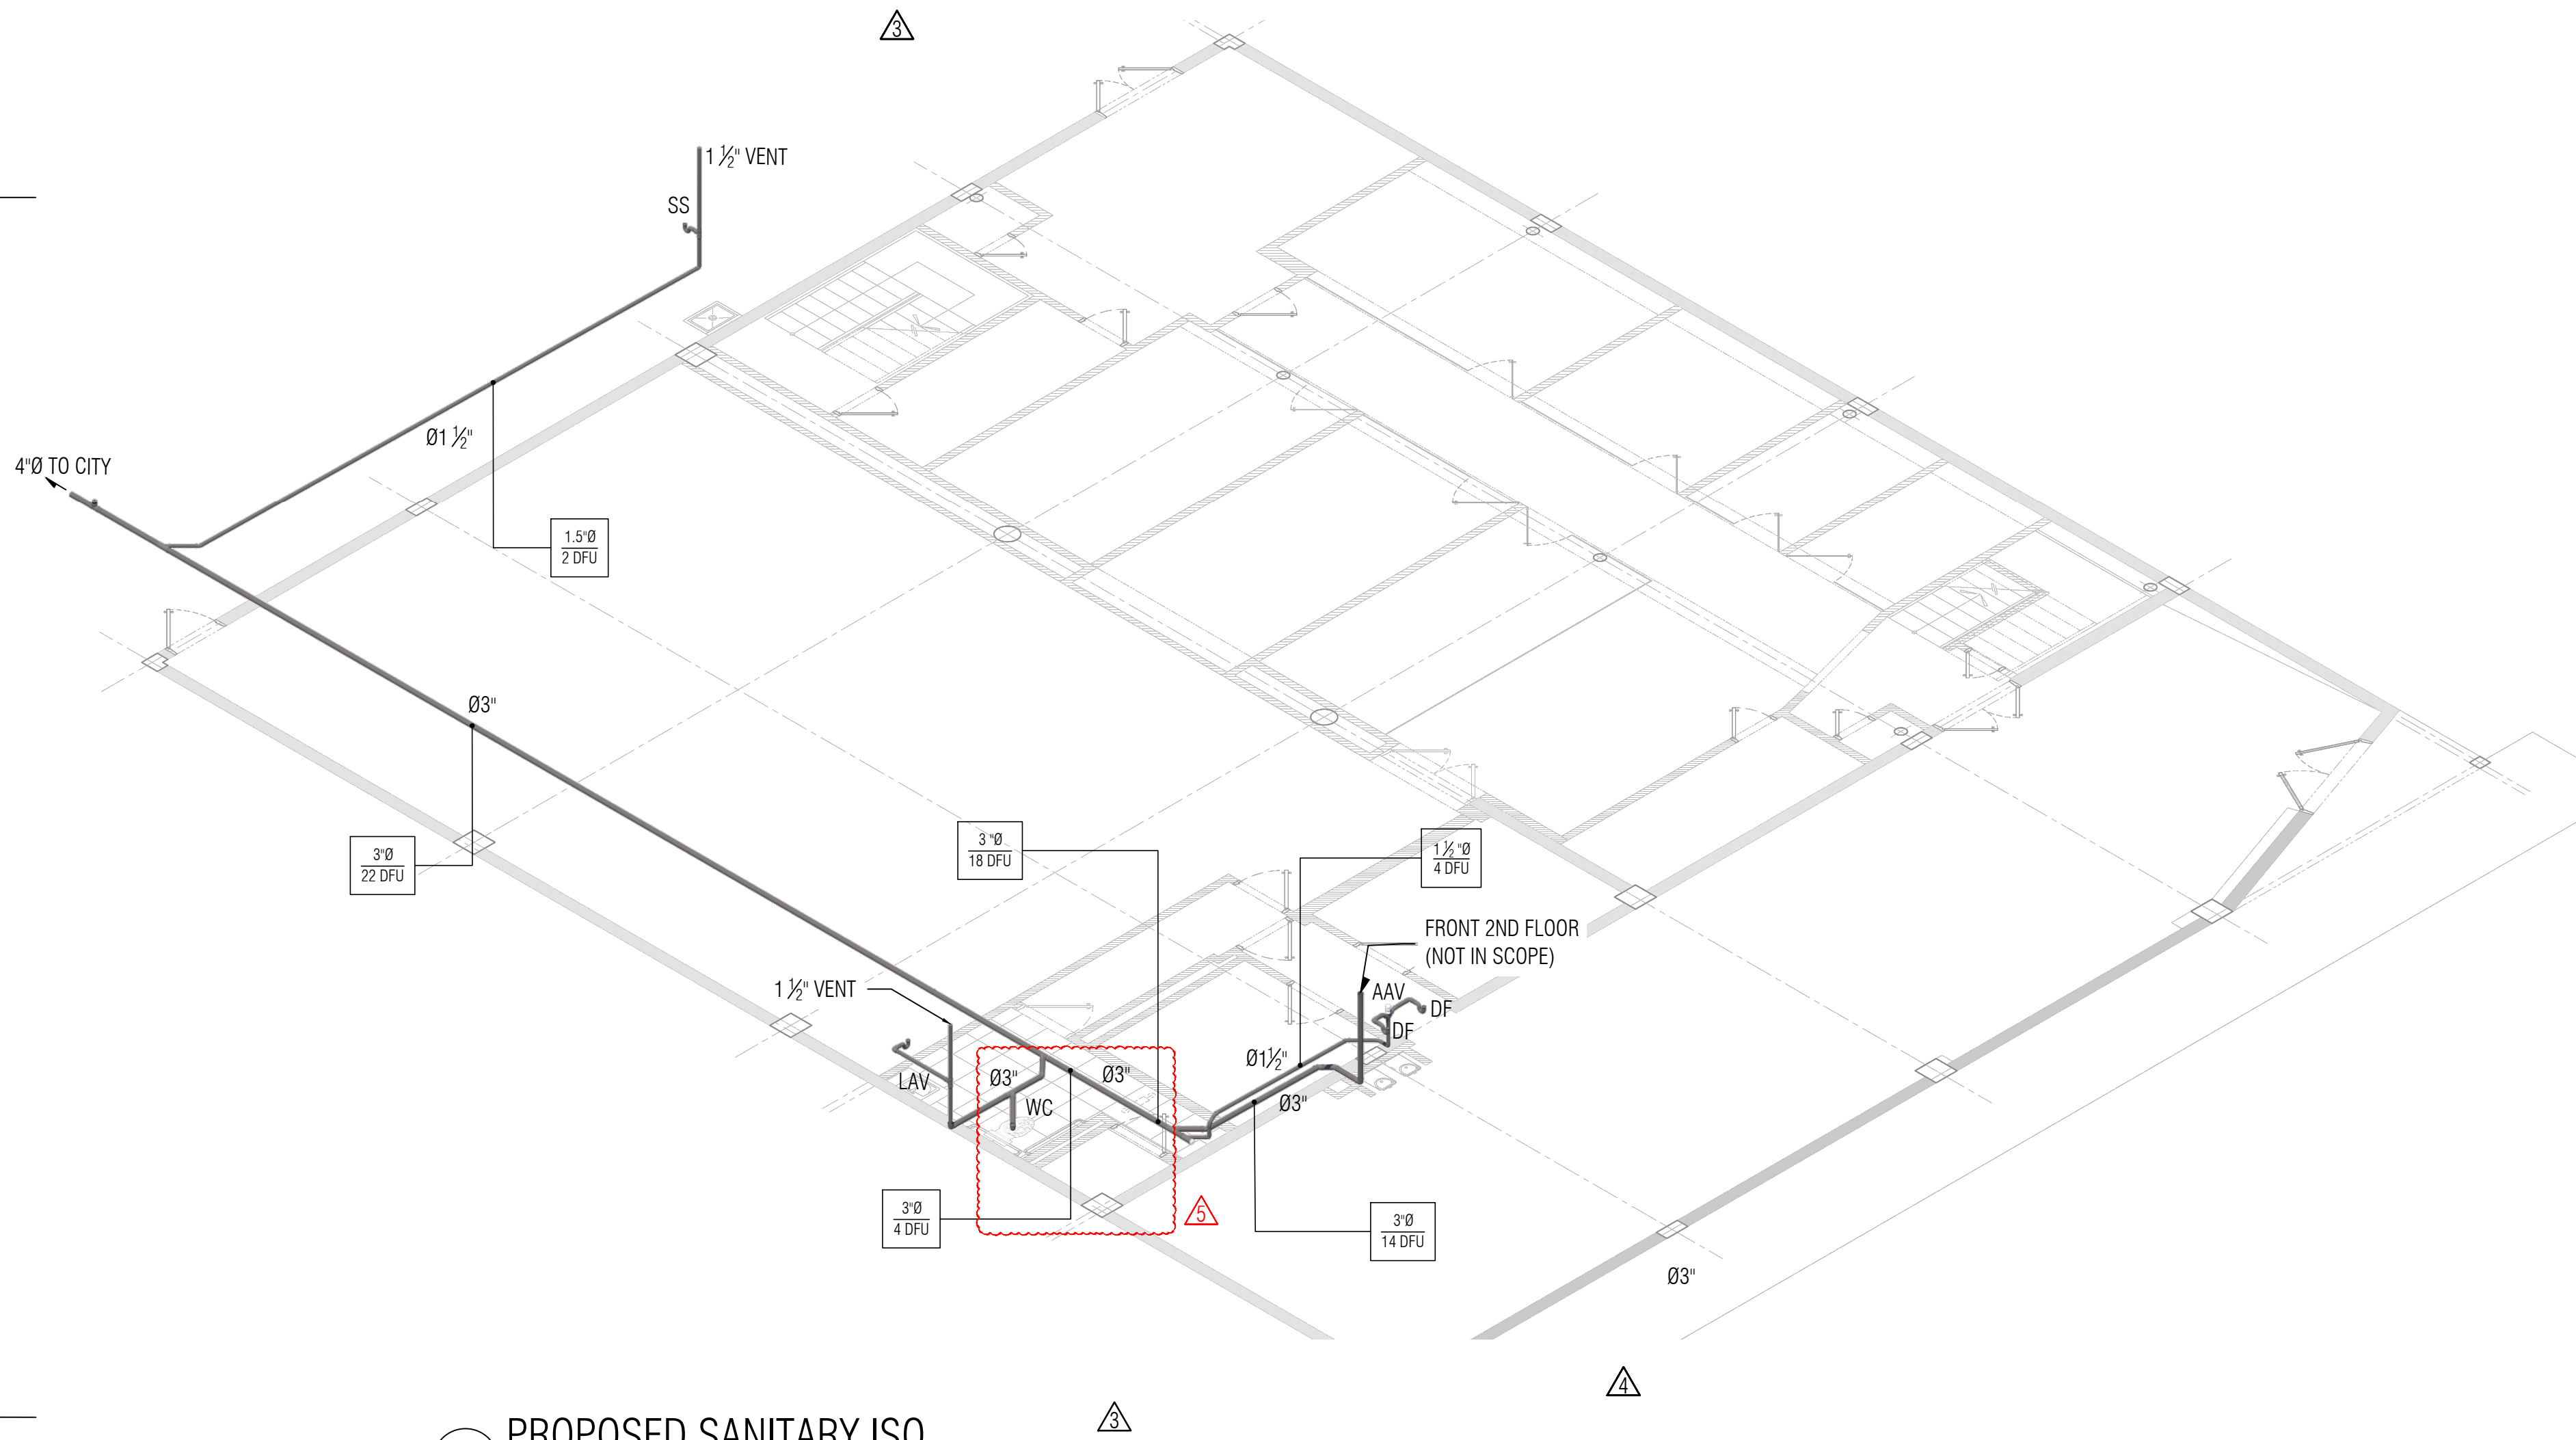

2 PROPOSED SANITARY ISO
 N.T.S.

DRAINAGE FIXTURE UNITS FBC PLUMBING, TABLE 709.1			
FIXTURE	DFU	EX. QUANTITY	EX. DFU
LAVATORY	1	1	1
WATERCLOSET	3	1	3
DRINKING FOUNTAIN	2	2	4
SERVICE SINK	2	1	2
FROM 2ND FLOOR (NOT IN SCOPE)	14	1	14
TOTAL			24

MINIMUM TRAP SIZES FBC PLUMBING, TABLE 709.1	
FIXTURE TYPE	MIN. TRAP SIZE (INCHES)
LAVATORY	1 1/2"
SHOWER (<5.7 GPM)	1 1/2"
SERVICE SINK	1 1/2"

NOTE:
 ALL DRAIN & VENT MATERIAL SHALL BE PVC, SCHEDULE 40, UNLESS OTHERWISE NOTED.

ISSUE	DATE
2. CITY OF MIAMI COMMENTS	11/04/2022
3. CITY OF MIAMI COMMENTS	12/23/2022
4. CITY OF MIAMI COMMENTS	01/27/2023
5. CITY OF MIAMI COMMENTS	02/01/2023

AMERICANO MEDIA GROUP STUDIO
 2920 NW 7 ST
 MIAMI, FL 33125

PROJECT:
 INTERIOR REMODELING

PLUMBING SANITARY PLAN

7875 NW 12th Street, Ste. 101
 Doral, FL 33126
 (786) 762-2204
 www.ves-us.com
 C.A. #32810

FELIX F. RODRIGUEZ, PE, SE
 FLORIDA PE #74481
 Civil, Structural, Mechanical
 admin@ves-us.com

VDES PROJECT #220078

DATE
 08/15/2022

SHEET
P-12