



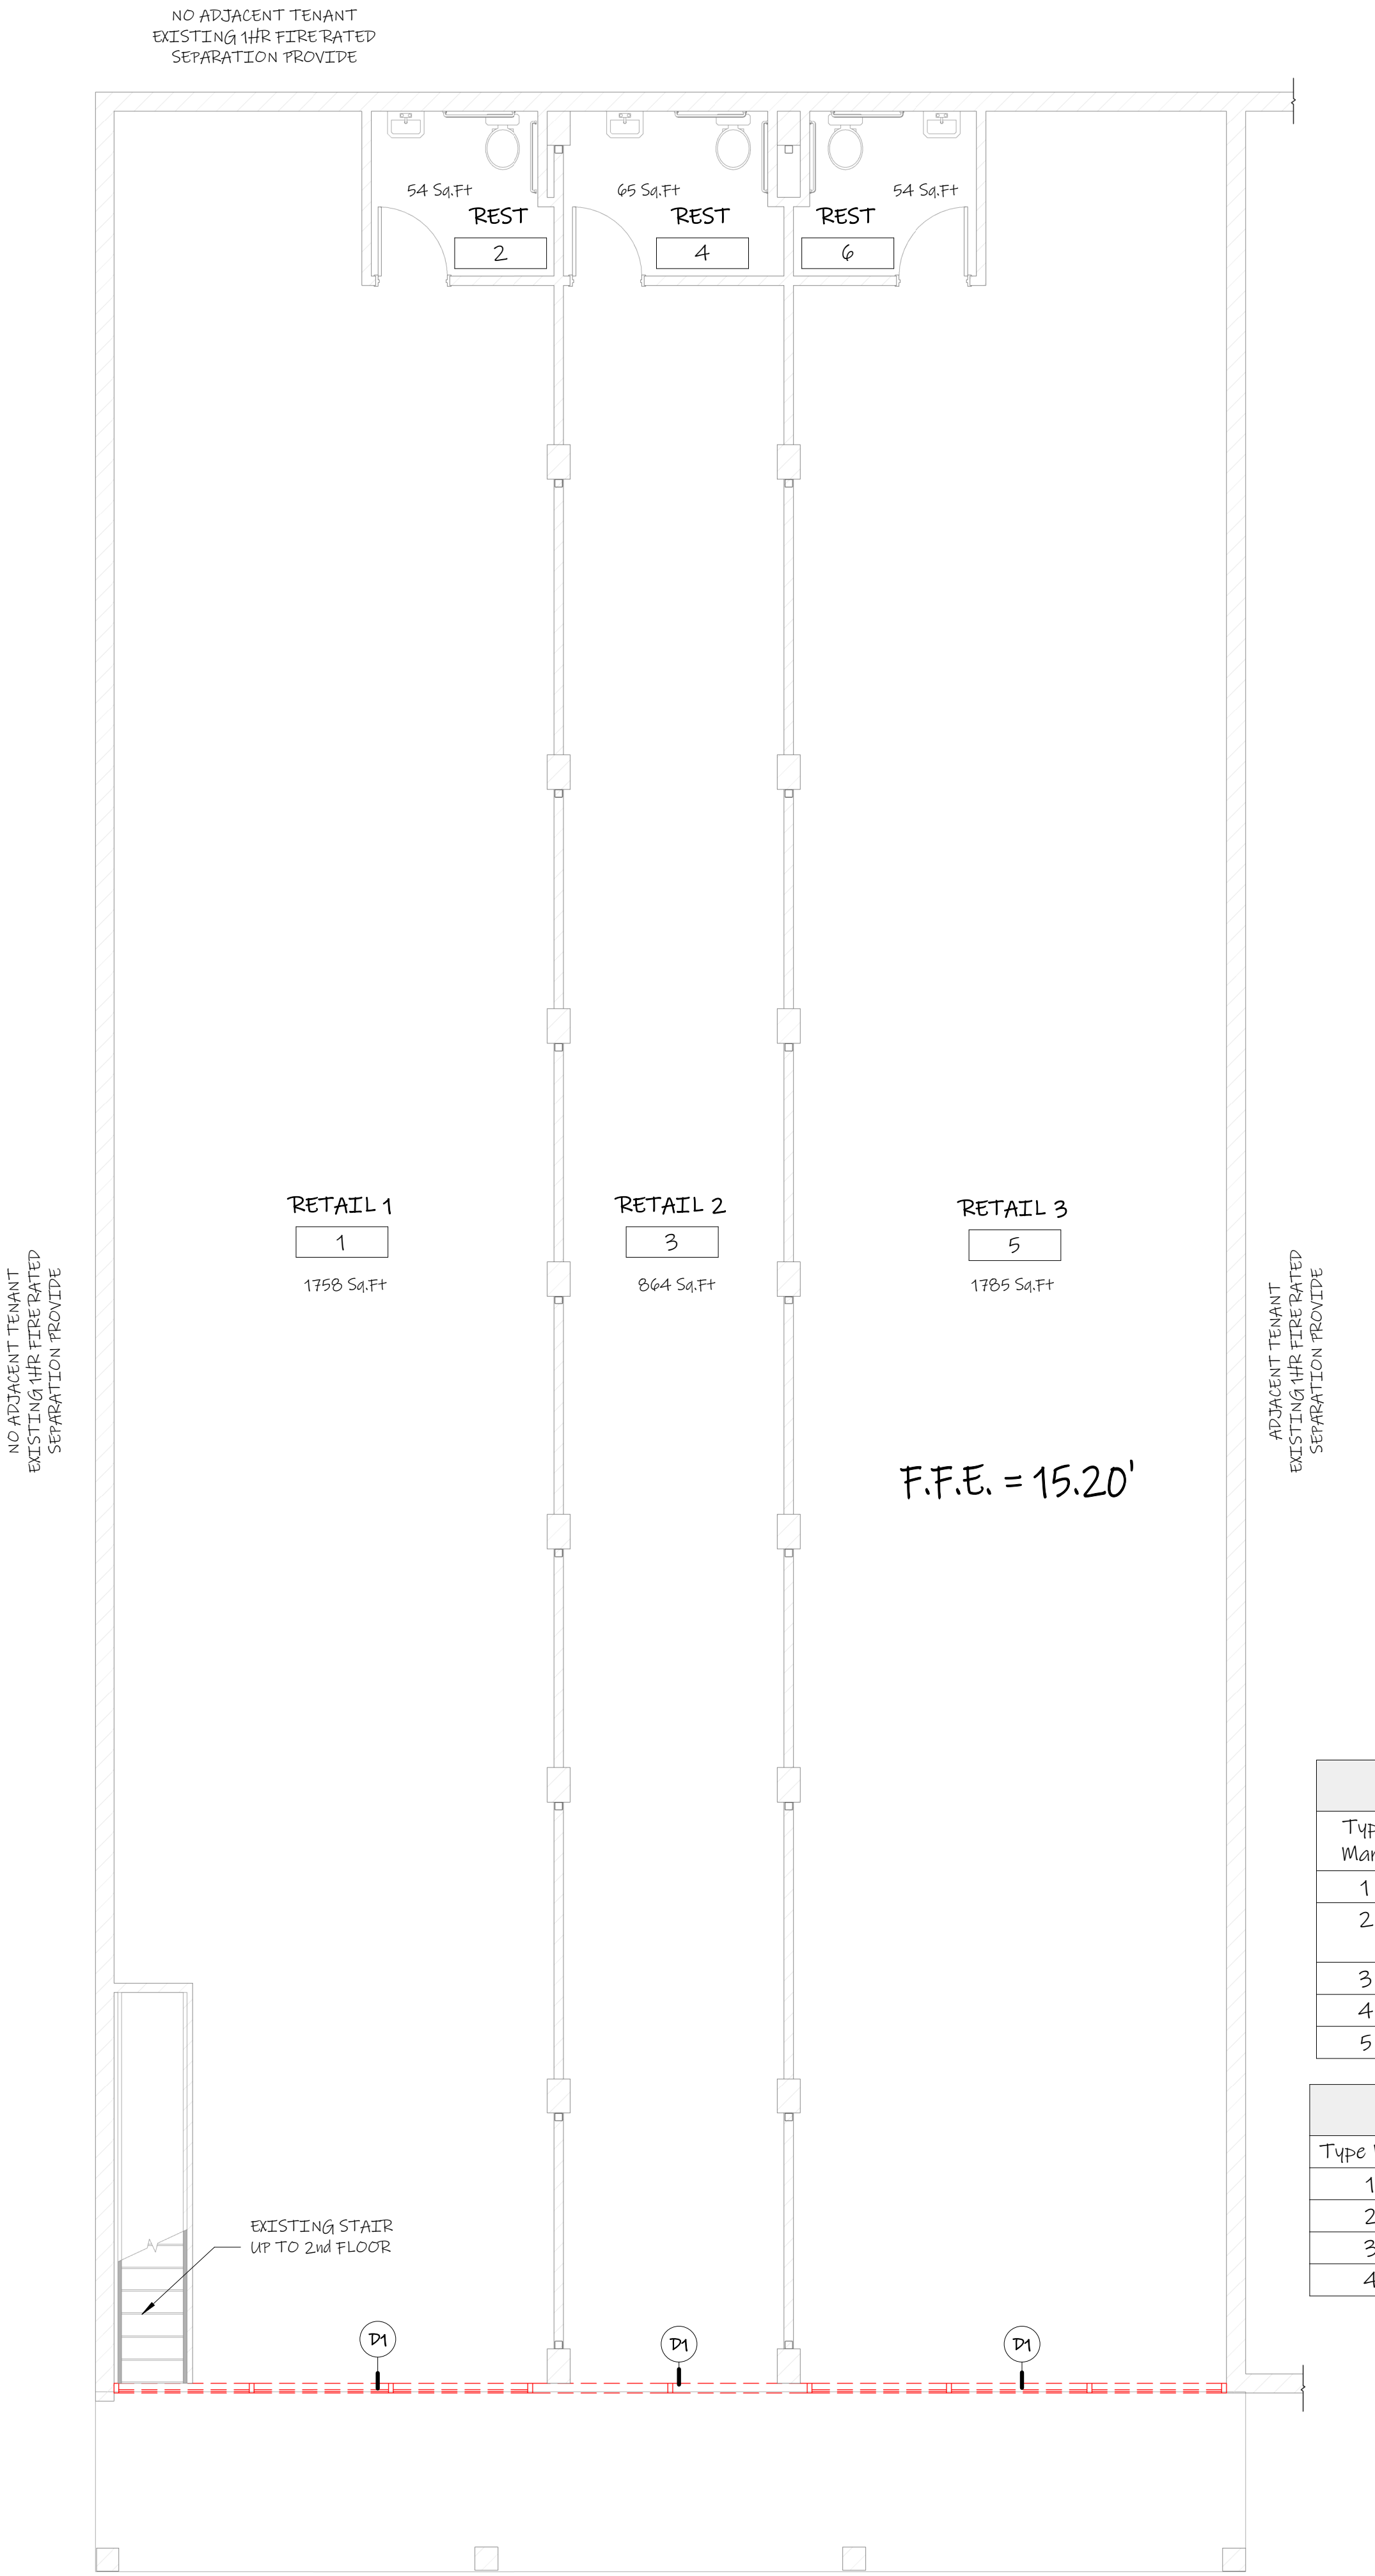

1 EXIST. FIRST FLOOR
3/16" = 1'-0"

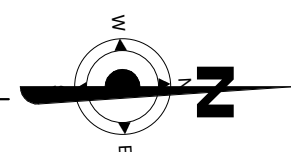

LEGEND

- TO BE DEMOLISHED
- EXIST. WALL TO REMAIN
- NOT IN SCOPE
- NEW WOOD FRAMING WALL
- NEW CONC. BLOCK WALL
- DOOR TAG
- WALL TAG
- WINDOW TAG

DEMOLITION LEGEND

D1	REMOVE EXIST. STOREFRONT
D2	REMOVE EXIST. PARTITION WALL
D3	REMOVE EXIST. DOOR
D4	REMOVE EXIST. PLUMBING FIXTURES AND CAP-OFF PIPES
D5	REMOVE EXIST. CONCRETE BLOCK WALL

PROPOSED LEGEND


N1	NEW STOREFRONT (BY OTHERS)
N2	NEW PARTITION WALL
N3	NEW DOOR (SEE SCHEDULE)
N4	AHU
N6	NEW LOADCENTER
N7	NEW PLUMBING FIXTURES
N8	NEW WINDOW (SEE SCHEDULE)
N9	NEW GLASS RAILING
N10	NEW STEEL COLUMN (SEE STRUCTURAL PLANS)
N11	BLOCK UP WALL OPENING
N12	NEW CONCRETE BLOCK WALL

- NOTE:
- STOREFRONT NOA # 20-0828.03

Door Schedule							
Type Mark	Operation	Frame Material	Width	Height	Zone-4	Zone-5	NOA#
1	BIFOLD	FULL LOWERED	32"				
2	DOUBLE SWING	ALUMINUM & GLASS	65"	94"			
3	SWING	ALUMINUM & GLASS	33"	94"			
4	SWING	ALUMINUM & GLASS	32"	80"			
5	SWING	WOOD	36"	84"			

Window Schedule							
Type Mark	Family	Width	Height	Zone 4	Zone 5	NOA #	Comments
1	Window-Fixed	84"	74"				
2	Window-Fixed	48"	92"				
3	Window-Fixed	74"	51"				
4	Window-Fixed	37"	64"				

- NOTE:
- EXTERIOR DOOR ARE UNDER SEPARATE PERMIT

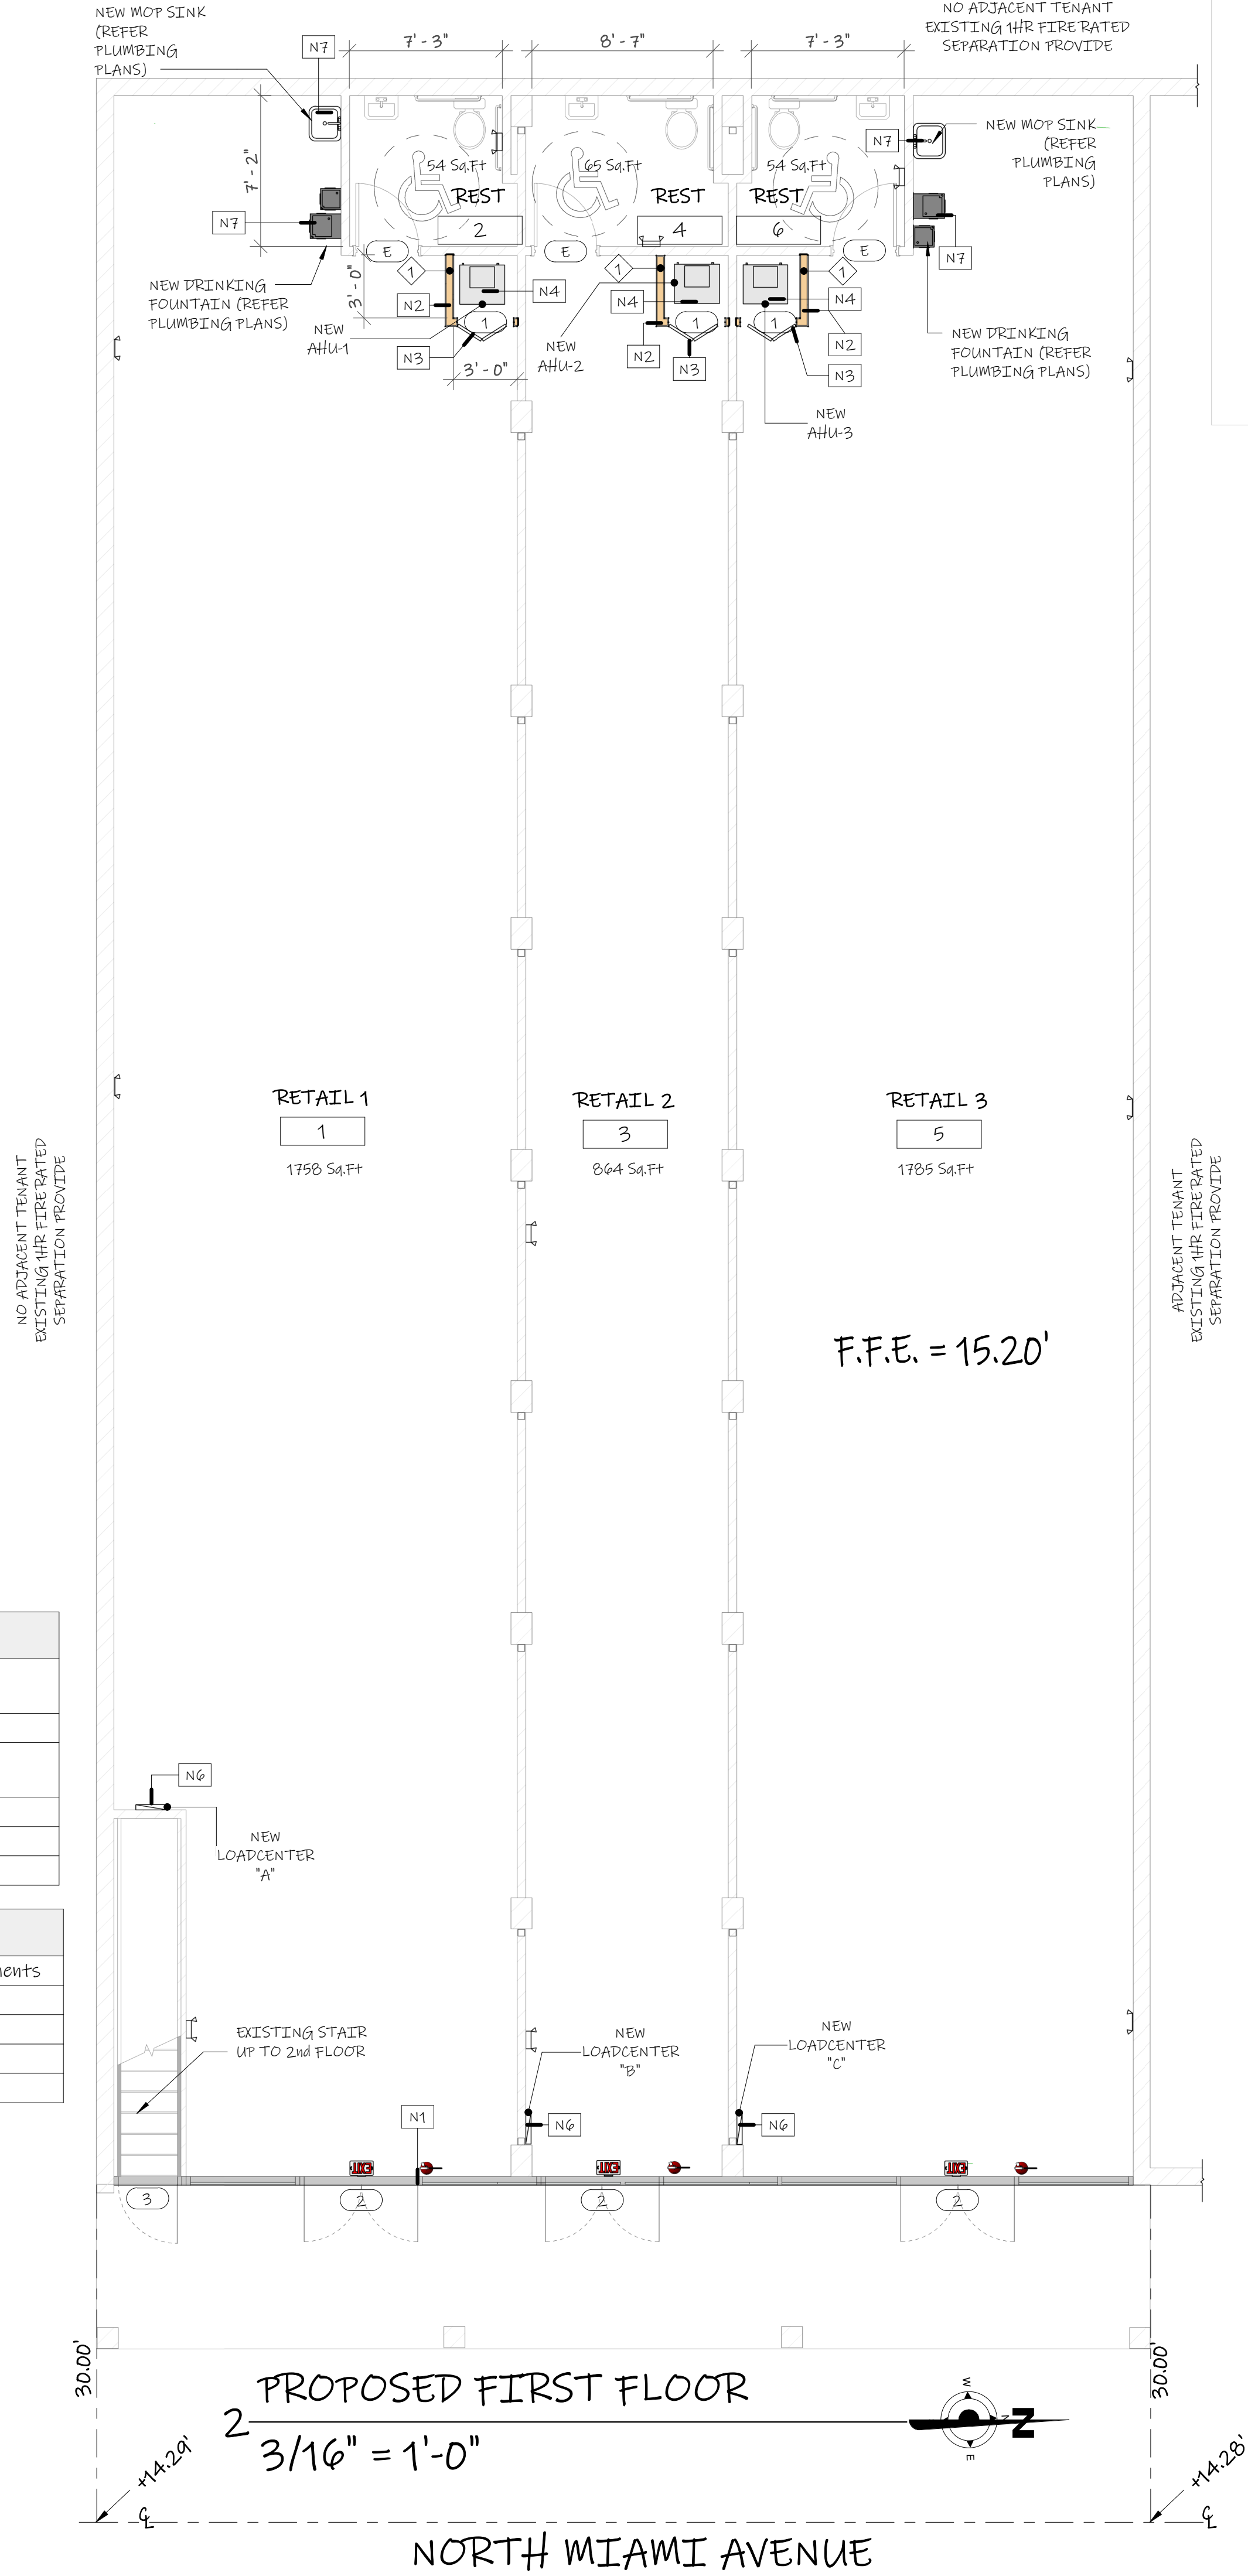

Calc
Engineering

CALC ENGINEERING
www.calceng.com
2000 NW 89th PL. #102
DORAL, FL 33172
Phone: (305) 898-9995
ENGINEERING BUSINESS
CA CERTIFICATION: 32566
MASOOD HAJALI P.E.
LIC #82038

INTERIOR REMODELING
ARENA PROPERTIES LLC @
532 N Miami Ave
Miami, FL 33136

Revision #	Description	Date

FIRST FLOOR
PLAN

Date	06/09/2022
Project Number	22183
Sheet	A.2
Scale	As indicated
Draw by	HH