


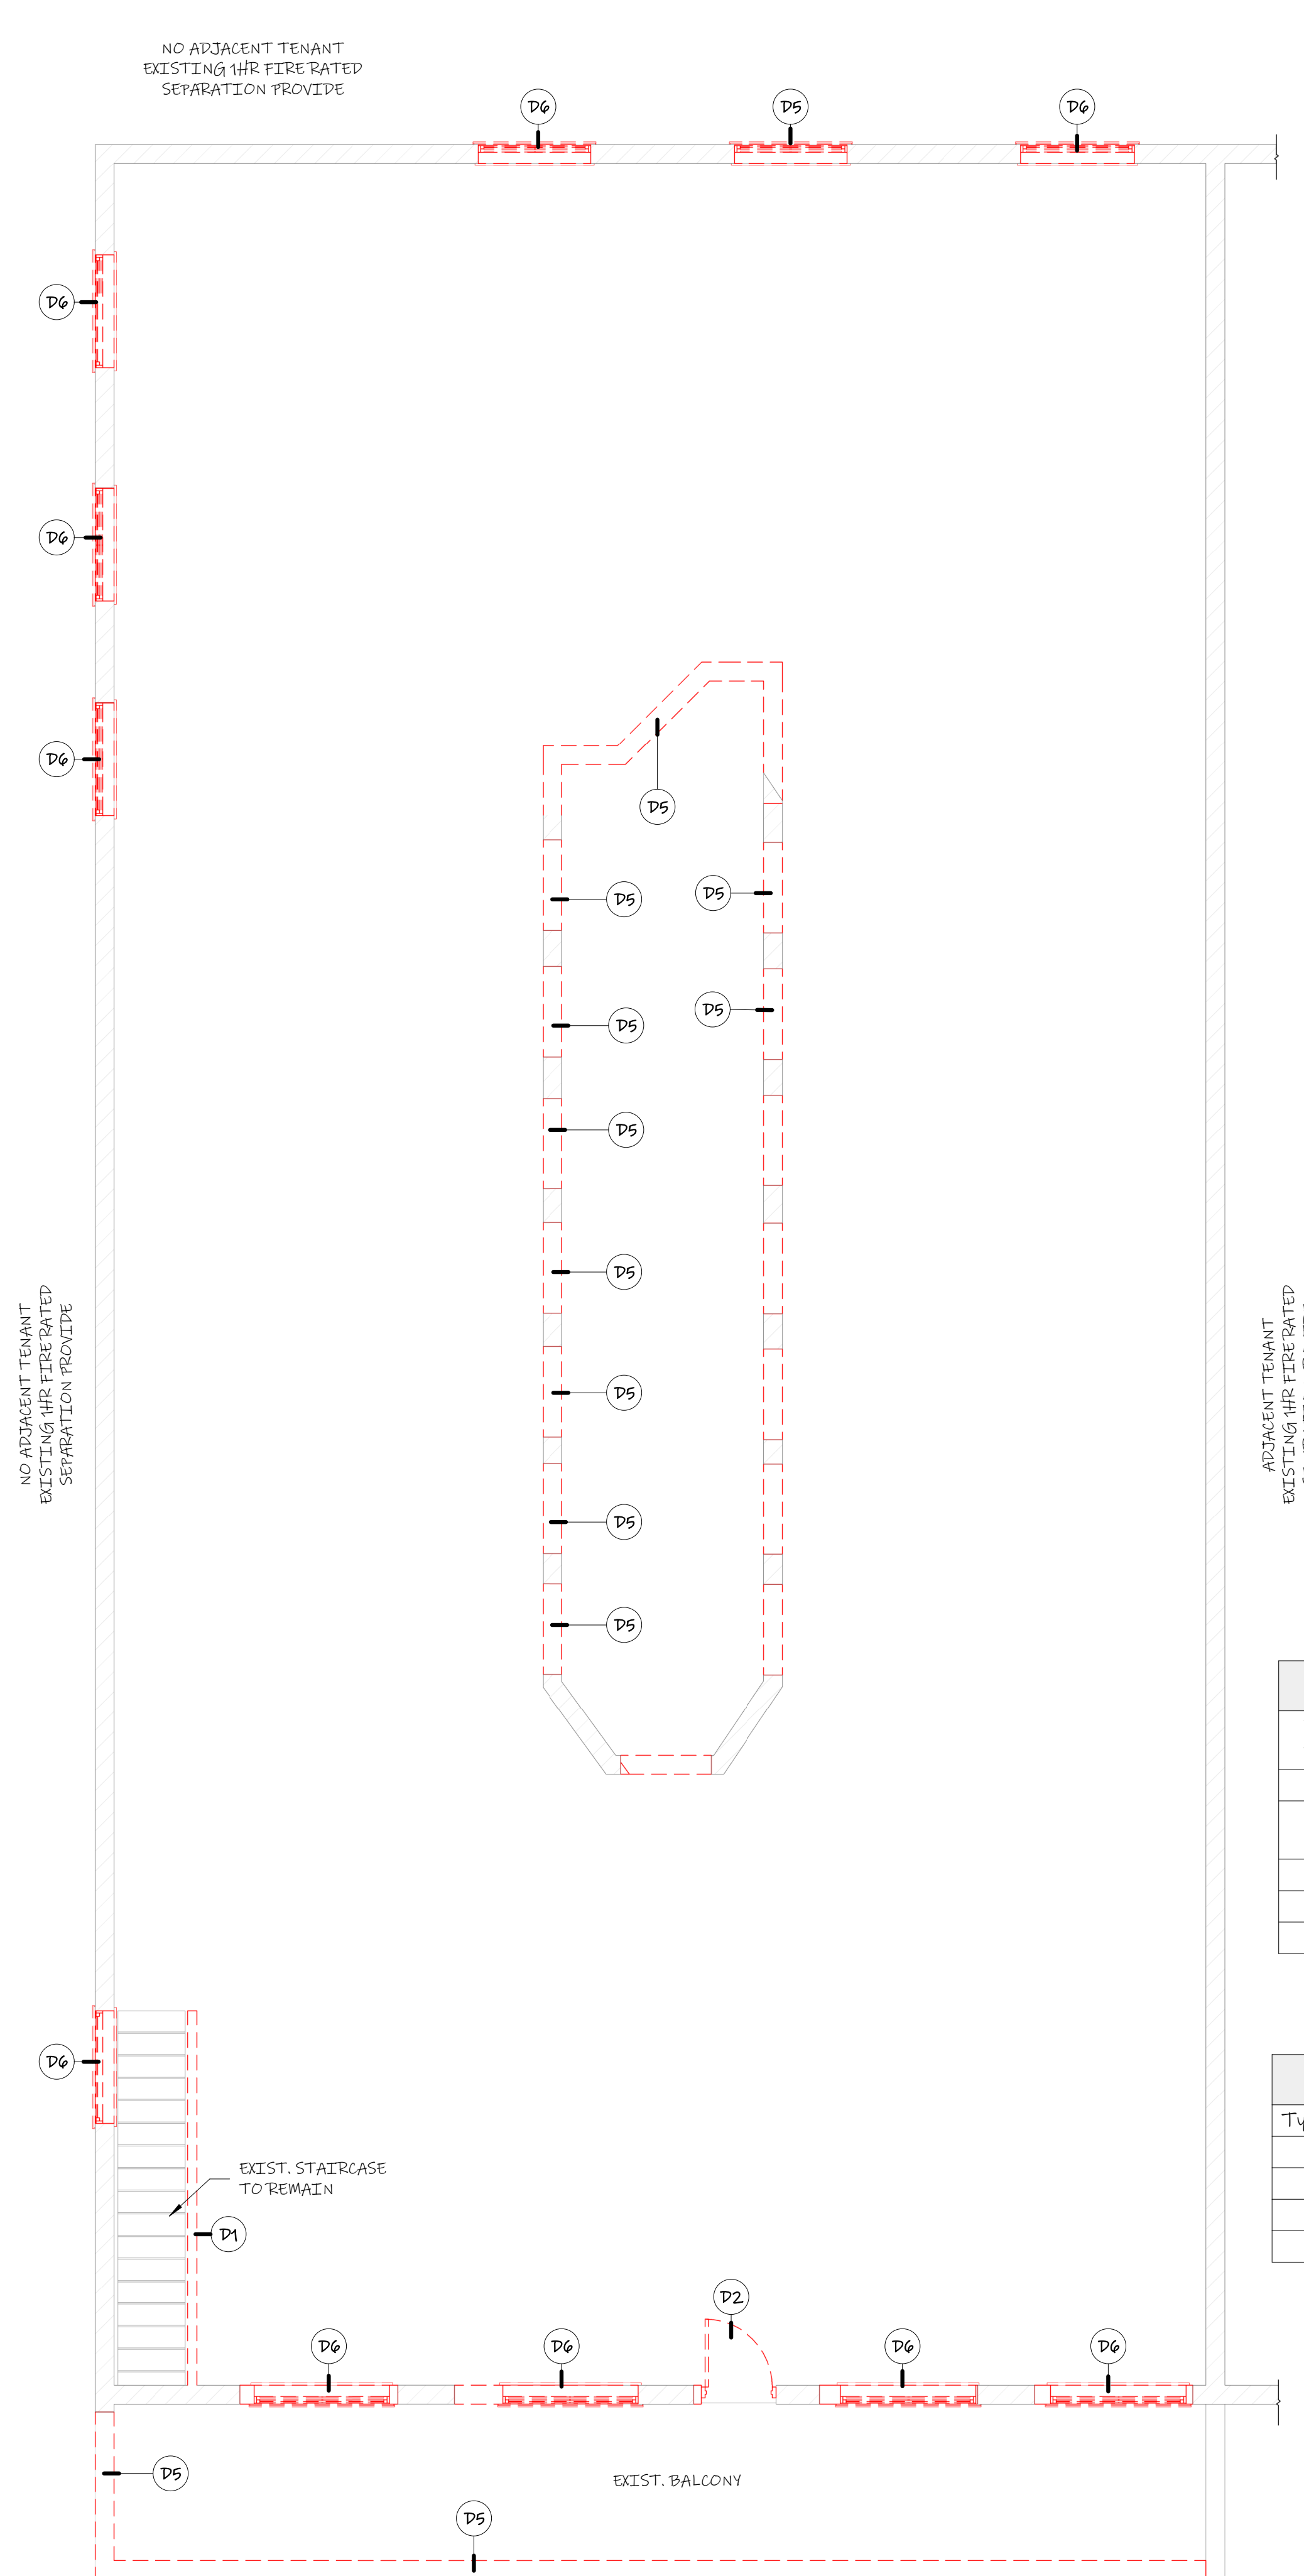

- LEGEND
- TO BE DEMOLISHED
 - EXIST. WALL TO REMAIN
 - NOT IN SCOPE
 - NEW WOOD FRAMING WALL
 - NEW CONC. BLOCK WALL
 - DOOR TAG
 - WALL TAG
 - WINDOW TAG



DEMOLITION LEGEND	
D1	REMOVE EXIST. STOREFRONT
D2	REMOVE EXIST. PARTITION WALL
D5	REMOVE EXIST. CONCRETE BLOCK WALL
D6	REMOVE EXIST. WINDOW

PROPOSED LEGEND	
N1	NEW STOREFRONT (BY OTHERS)
N2	NEW PARTITION WALL
N3	NEW DOOR (SEE SCHEDULE)
N4	AHU
N6	NEW LOADCENTER
N7	NEW PLUMBING FIXTURES
N8	NEW WINDOW (SEE SCHEDULE)
N9	NEW GLASS RAILING
N10	NEW STEEL COLUMN (SEE STRUCTURAL PLANS)
N11	BLOCK UP WALL OPENING
N12	NEW CONCRETE BLOCK WALL


Door Schedule							
Type Mark	Operation	Frame Material	Width	Height	Zone-4	Zone-5	NOA#
1	BIFOLD	FULL LOUVERED	32"	94"			
2	DOUBLE SWING	ALUMINUM & GLASS	65"	94"			
3	SWING	ALUMINUM & GLASS	33"	94"			
4	SWING	ALUMINUM & GLASS	32"	80"			
5	SWING	WOOD	36"	84"			

Window Schedule							
Type Mark	Family	Width	Height	Zone 4	Zone 5	NOA #	Comments
1	Window-Fixed	84"	74"				
2	Window-Fixed	48"	92"				
3	Window-Fixed	74"	51"				
4	Window-Fixed	37"	64"				

1 EXIST. SECOND FLOOR
3/16" = 1'-0"

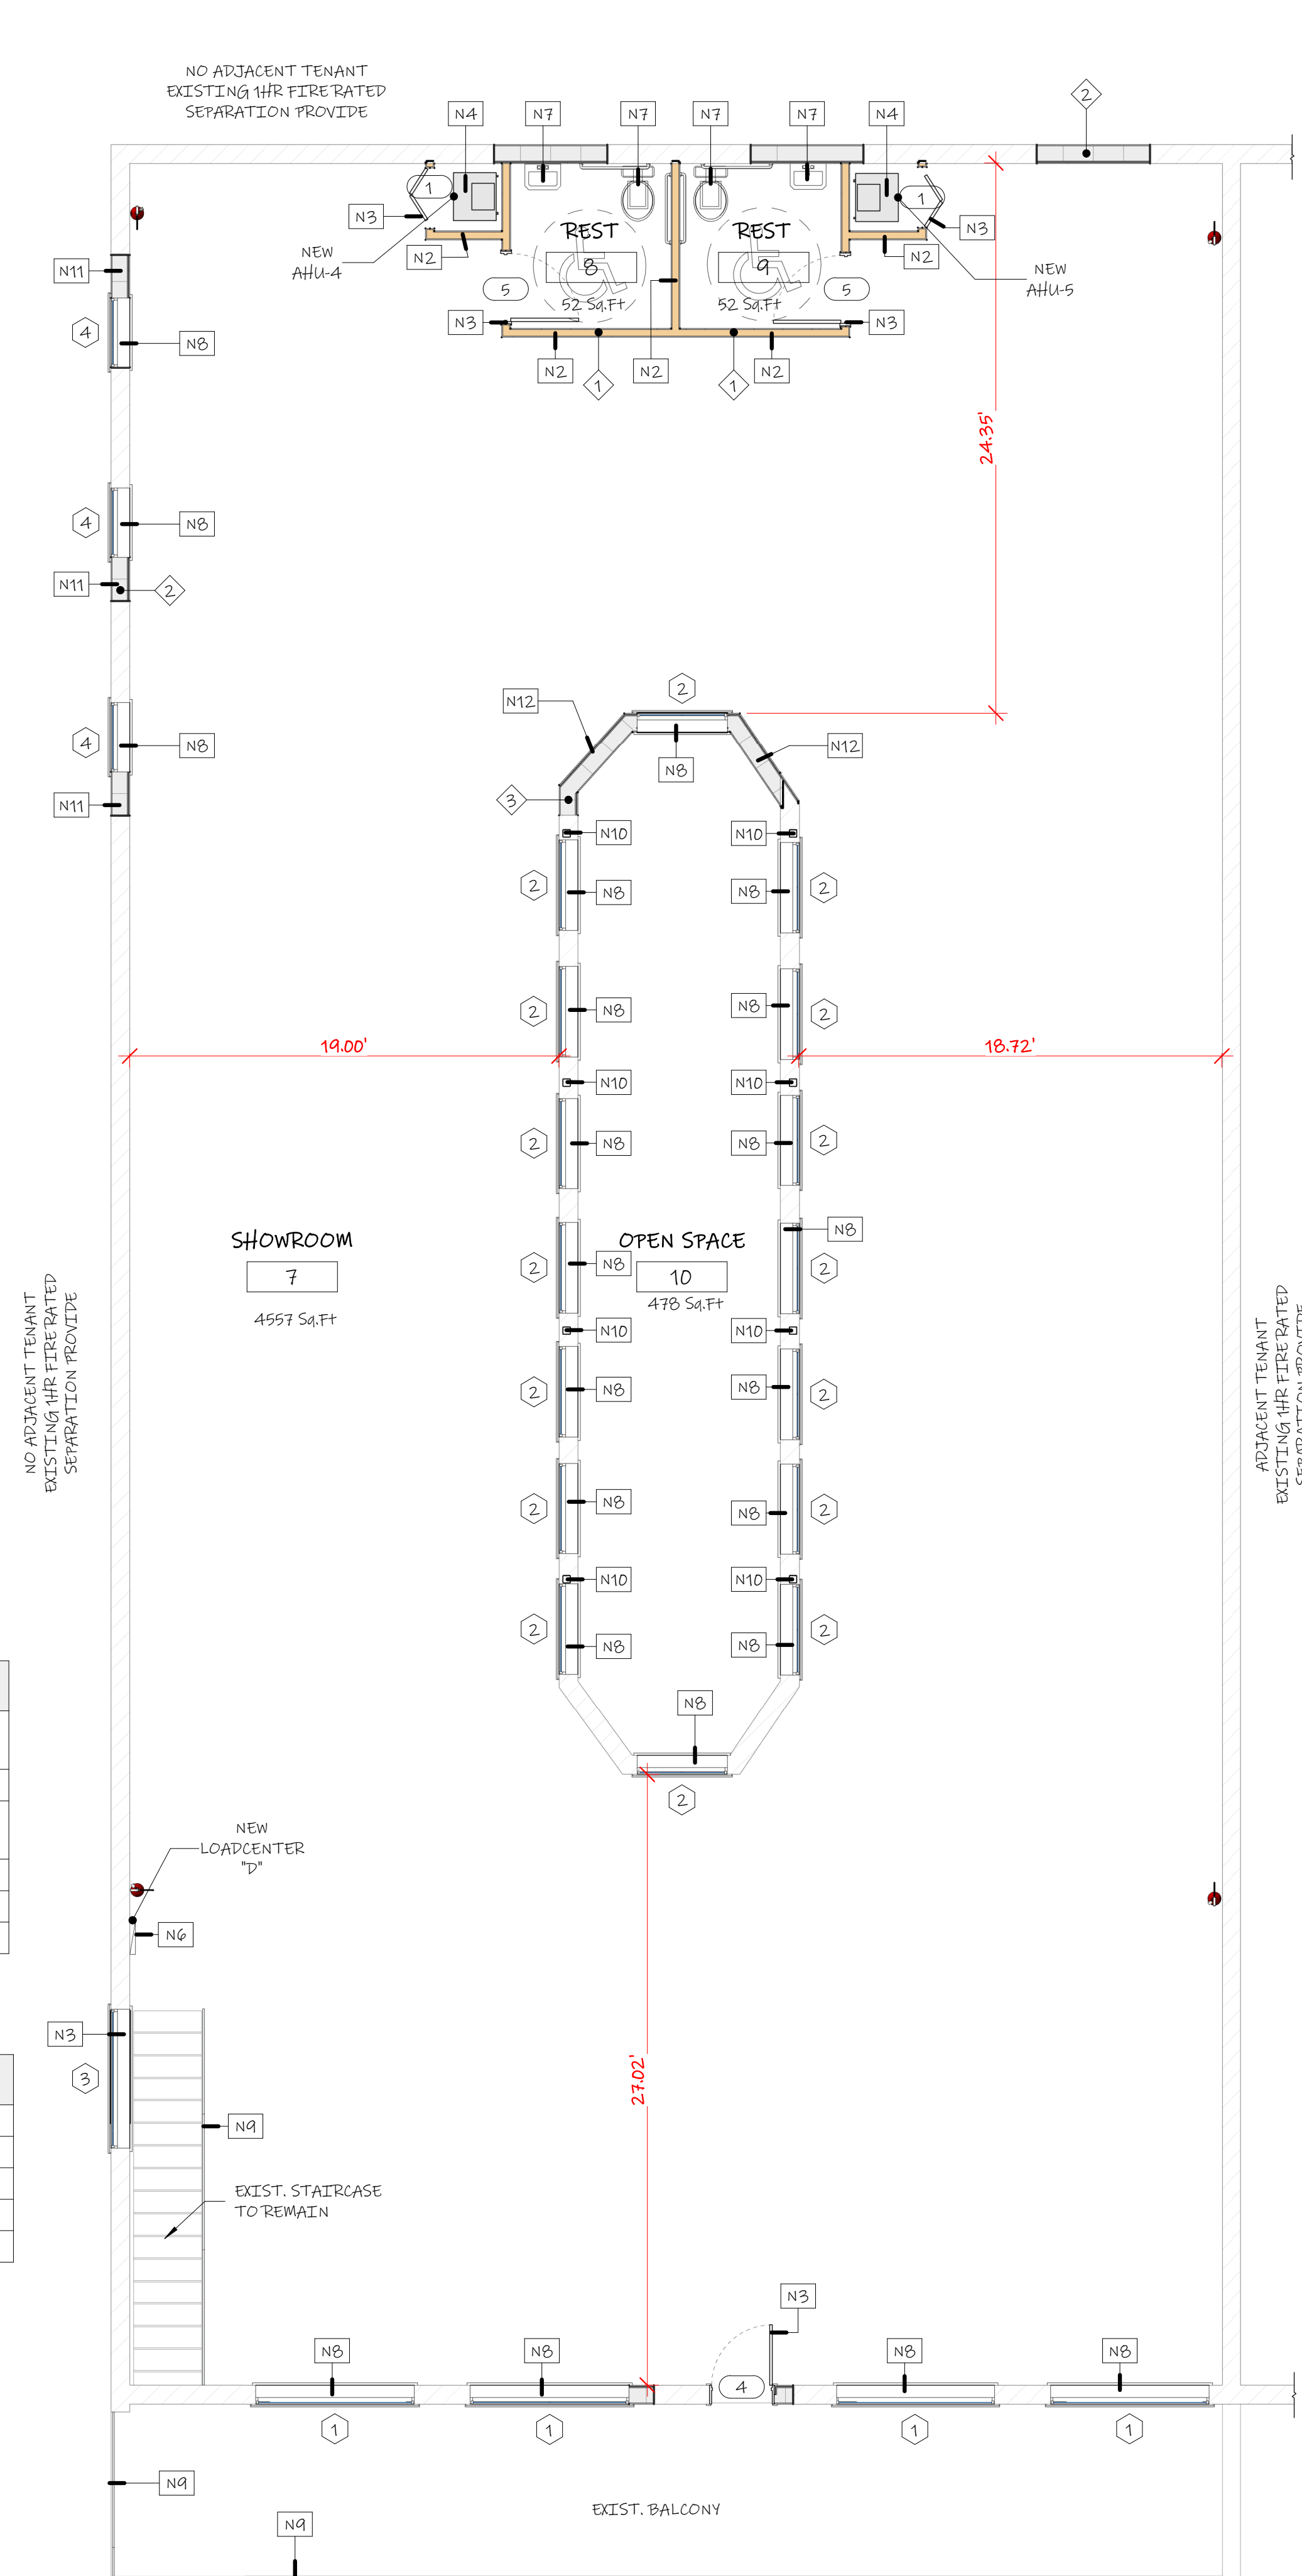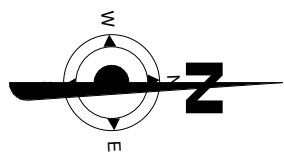

2 PROPOSED SECOND FLOOR
3/16" = 1'-0"

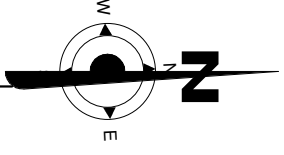

Calc
Engineering

CALC ENGINEERING
www.calceng.com
2000 NW 89th PL. # 102
DORAL, FL 33172
Phone: (305) 898-9995
ENGINEERING BUSINESS
CA CERTIFICATION: 32566
WASOOD HAJALI P.E
LIC #B2038

INTERIOR REMODELING
ARENA PROPERTIES LLC @
532 N Miami Ave
Miami, FL 33136

Revision #	Description	Date

SECOND FLOOR PLAN	
Date	06/09/2022
Project Number	22183
Sheet	A.3
Scale	As indicated
Draw by	HH

DESIGN IS BASED ON FBC 2020, 7TH EDITION